

GENERAL NOTES & DESIGN CRITERIA

This plan was designed and drafted by Design Basics, Inc. to meet average conditions and codes in the State of Nebraska at the time it was designed. This plan was also designed for seismic zone 1. Because codes and requirements can change and may vary from jurisdiction to jurisdiction, Design Basics, Inc. cannot warrant compliance with any specific code or regulation. Consult your local building official to determine the suitability of these plans for your specific site and application. This plan can be adapted to your local building codes and requirements, but also, it is the responsibility of the purchaser and/or builder of this plan to see that the structure is built in strict compliance with all governing municipal codes (city, county, state and federal). The purchaser and/or builder of this plan releases Design Basics, Inc., its shareholders, directors, officers, and employees from any claims or lawsuits that may arise during the construction of this structure or anytime thereafter.

- DESIGN LOADS:**
- * Floor: 40 psf. live
 - * Roof: 30 psf. live
 - * Ceiling: 10 psf. live
 - * 15 psf. dead
 - * 10 psf. dead
 - * Soil bearing Capacity - 2000 PSF
 - * Live loads, dead loads, wind loads, snow loads, lateral loads, seismic zoning and any specially loading conditions will need to be confirmed before construction and adjustments to plans made accordingly. See your local building officials for verification of your specific load data, zoning restrictions and site conditions.

- CONCRETE AND FOUNDATIONS:**
- * All foundation walls and slabs on grade shall be 3000 PSI (28-day compressive strength concrete), unless noted otherwise.
 - * All interior slabs on grade shall bear on 4" compacted granular fill with 6 mil. polyethylene vapor barrier underneath.
 - * Provide proper expansion and control joints as per local requirements.
 - * All 36" x 36" x 18" concrete pads to have (3) #5 rods each way.
 - * All 48" x 48" x 18" concrete pads to have (4) #5 rods each way.
 - * Foundation walls are not to be backfilled until properly braced.
 - * Verify depth of frost footings with your local codes.
 - * Provide termite protection as required by HUD minimum property standards.
 - * Foundation bolts must be anchored to sill plate with 1/2" bolts embedded 15" in concrete walls.

REBAR & BOLT SCHEDULE:


BAR SIZE AND SPACING	VERTICAL	HORIZONTAL
8" Wall thickness	#5 @ 16 o.c.	#5 @ 16 o.c.
10" Wall thickness (w-brick)	#5 @ 12 o.c.	#5 @ 16 o.c.

EXTERIOR FILL	BOLT SPACING
0" to 3'-6"	72" o.c.
3'-7" to 6'-0"	48" o.c.
6'-1" to 7'-0"	32" o.c.
Over 7'-0"	Additional engineering may be required

- STEEL:**
- * All structural steel for beams and plates shall comply with ASTM specification A-36.
 - * All structural steel for steel columns shall comply with ASTM specification A-53 Grade B or A-501.
 - * All reinforcing steel for concrete shall comply with ASTM specification A-615 Grade 60.
 - * Provide steel shims in all beam pockets.
 - * Steel columns are to be 3" I.D. (inside diameter) unless noted otherwise.


- FRAMING MEMBERS:**
- * Unless noted otherwise, all framing lumber shall have the following characteristics:
Fv = 1,000 psi
E = 1,400,000 psi
 - * Contractor to confirm the size, spacing and stress characteristics of all framing and structural members to meet your local code requirements. Hole sizes and locations in G-1/4" or Laminated Veneered Lumber members are to be confirmed by a professional engineer.
 - * Any structural or framing members not indicated on the plan are to be sized by contractor.
 - * Double floor joists under all partition walls, unless noted otherwise.
 - * All subflooring is assumed to be 3/4" thick - Glue-nailed.
 - * All exterior walls are dimensioned to outside of 1/2" rigid insulation. All exterior walls are 4" (3 1/2" stud plus 1/2" rigid insulation). All interior walls are 3 1/2" unless otherwise shown.
 - * Calculated dimensions take precedence over scaled dimensions.
 - * All walls are 9'-1 1/8" high unless otherwise noted or implied.
 - * All angled walls on floor plans are at 45 degree angle, unless otherwise noted.

SYMBOLS

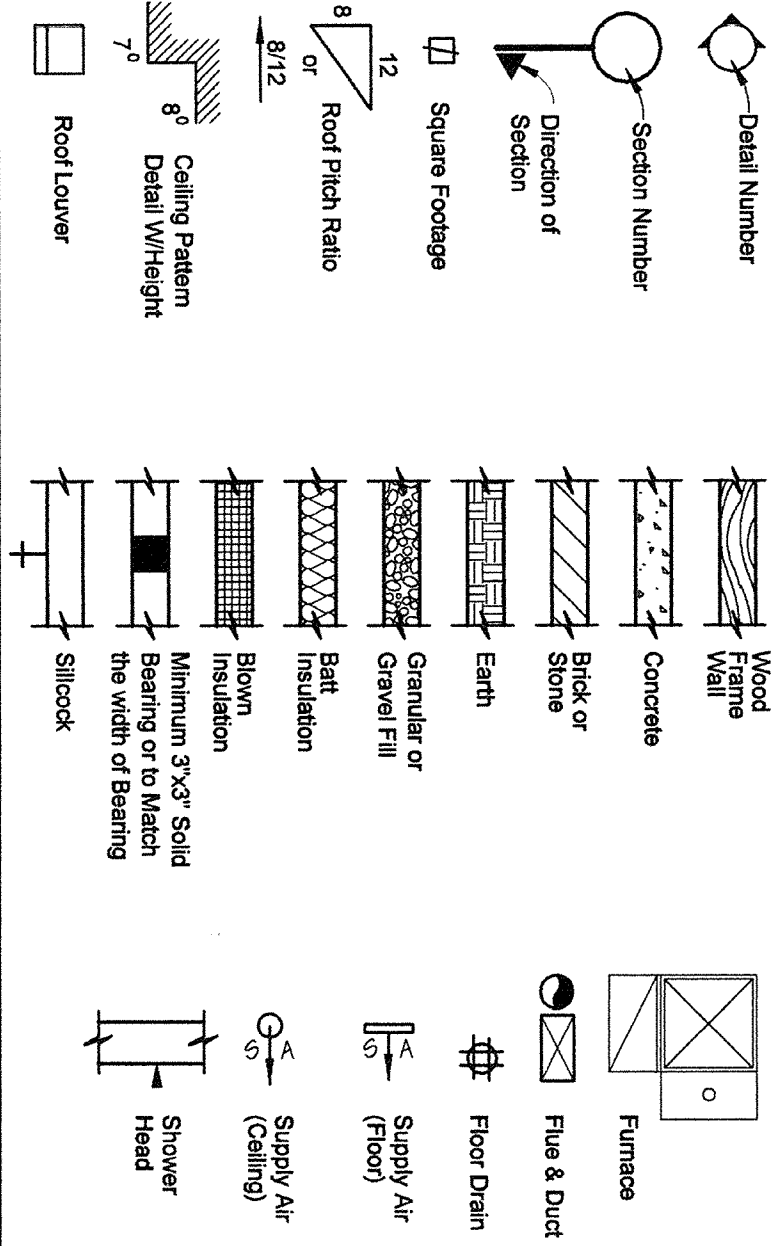

- FRAMING MEMBERS (continued):**
- * Any wall 12'-0" high or higher shall be 2x6 and balloon framed.
 - * Unless noted otherwise, above all openings that are:
(1) Load bearing and less than 3 ft. use 4x6.
(2) Load bearing and more than 3 ft. use (2) 2x12 w/1/2" Plywood between.
 - (3) Non-load bearing and less than 6 ft. use 2x6.
(4) Non-load bearing and more than 6 ft. use (2) 2x12 w/1/2" Plywood between.
 - (5) All exterior openings use (2) 2x12 w/1/2" Plywood between. All trusses to be engineered by truss manufacturer according to the loading indicated on this plan.
 - * All exterior corners shall be braced in each direction with let-in diagonal bracing or plywood.
 - * Place (1) row of "1" x 3" cross-bridging on all spans over 8'-0" and (2) rows of "1" x 3" cross-bridging on all spans over 16'-0".
 - * Collar ties are to be spaced 4'-0" o.c.
 - * All purllins and kickers are to be 2x6's, unless noted otherwise.
 - * Any hip or valley rafters over a 28'-0" span are to be Laminated Veneer Lumber (L.V.L.).

- MISC. NOTES:**
- * Prefabricated fireplaces and flues are to be U.L. approved and installed as per manufacturer's specifications.
 - * All materials, supplies and equipment to be installed as per manufacturer's specifications and as per local codes and requirements.
 - * Note: Provide proper insulation for all plumbing.
 - * 1/2" water-resistant drywall around showers, tubs and whirlpools.
 - * 1/2" drywall on interior walls and ceilings.
 - * 5/8" type "X" fire code drywall on garage walls and ceilings.
 - * Windows are called out by glass size only.
 - * Windows, if not noted, are assumed to be casements.
 - * Header heights are labeled to bottom of arched transoms.
 - * Confirm window openings for your local egress requirements and minimum light and ventilation requirements.
 - * Headroom at stairs shall have a minimum clearance of 6'-8" high.
 - * Provide proper handrails at stairs as per local code.
 - * The mechanical and electrical layouts are suggested only. Consult your mechanical and electrical contractors for exact specifications, locations and sizes.
 - * Jog line to read of ridge as necessary.
 - * Note: Provide proper wiring for all electrical appliances, mechanical equipment and whirlpools as per manufacturer's specifications.
 - * All air conditioner locations may vary depending on restrictive covenants and codes.
 - * Typical overhang sizes unless noted otherwise on drawing are as follows:
On pitches of 4/12 - 5/12 - 6/12 = 24" overhang
7/12 = 20" overhang
8/12 = 16" overhang
9/12 = 12" overhang
10/12 - 11/12 - 12/12 = 12" overhang
 - * Note: Adjust overhangs to provide clearance for windows to open. Adjust overhangs to maintain a consistent level when the plans call for (2) different pitches at a hip.
 - * Minor alterations to this plan can be made by builder. Please contact our drafting department for information and price quotes if major changes are required.
 - * Design Basics, Inc. determines finished square footage by measuring to the outside of all walls. We include: interior fireplaces and every location in which the floor joists project from the foundation. We do not include: window boxes where the floor joists do not project from the foundation; 2-story entries; exterior fireplaces; garage; decks; patios; porches; unfinished storage areas; basements or any other unfinished areas.

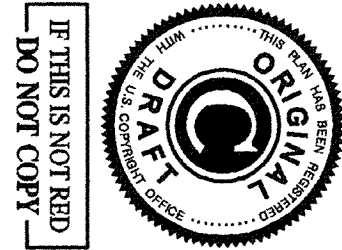

design basics inc.
HOME PLAN DESIGN SERVICE

ELECTRICAL LEGEND

110V OUTLET	FLOOD LIGHT
WALL SWITCHED 110V OUTLET	FLUORESCENT LIGHT
220V OUTLET	TRACK LIGHT
WEATHERPROOF 110V OUTLET	UNDER COUNTER LIGHT
GROUND FAULT 110V OUTLET	EXHAUST FAN
FLOOR 110V OUTLET	BRUSHED FANLIGHT COMBO
SPRINKLER MOUNT LIGHT	PADLOCK FANLIGHT FUTURE
RECESSED CAN LIGHT	PADLOCK FAN (WALL)
WALL MOUNT LIGHT	SMOKE DETECTOR (CEILING)
PULL-CORD SURFACE MOUNT LIGHT	TWO-WAY SWITCH
THERMOSTAT	FOUR-WAY SWITCH

NOTE: WIRE, SMOKE DETECTORS IN SERIES


ABBREVIATIONS

A/C	Air Conditioner	INSUL	Insulation	PROJ	Projection	TRAP	Trapzoid
AC	Attic	IS	Isolator	RA	Refrigerator	UNEX	Unexcavated
AD	Asbestos	LVL	Laminated Veneer Lumber	REFRIG	Refrigerator	WASH	Washer
ADU	Accessory Dwelling Unit	MAX	Maximum	SEC	Second	WH	Water Heater
ADU	Accessory Dwelling Unit	MBR	Master Bedroom	SHWR	Shower	W.W.M.	Water Wastewater
ADU	Accessory Dwelling Unit	MIN	Minimum	SPP	Stump Pump Pit	@	At
ADU	Accessory Dwelling Unit	MISC	Miscellaneous	STA	Stationary	3W	Three Wide
ADU	Accessory Dwelling Unit	O.H.D.	Overhead Door	STL	Steel	4W	Four Wide
ADU	Accessory Dwelling Unit	OPNG	Opening	STRCT	Structural	W	Water
ADU	Accessory Dwelling Unit	PCT	Polyethylene	T & G	Tongue & Groove		Diameter
ADU	Accessory Dwelling Unit			TRANS	Transom		

ARTIST CONCEPTION ONLY

ARTWORK NOT TO SCALE

ROSEDALE

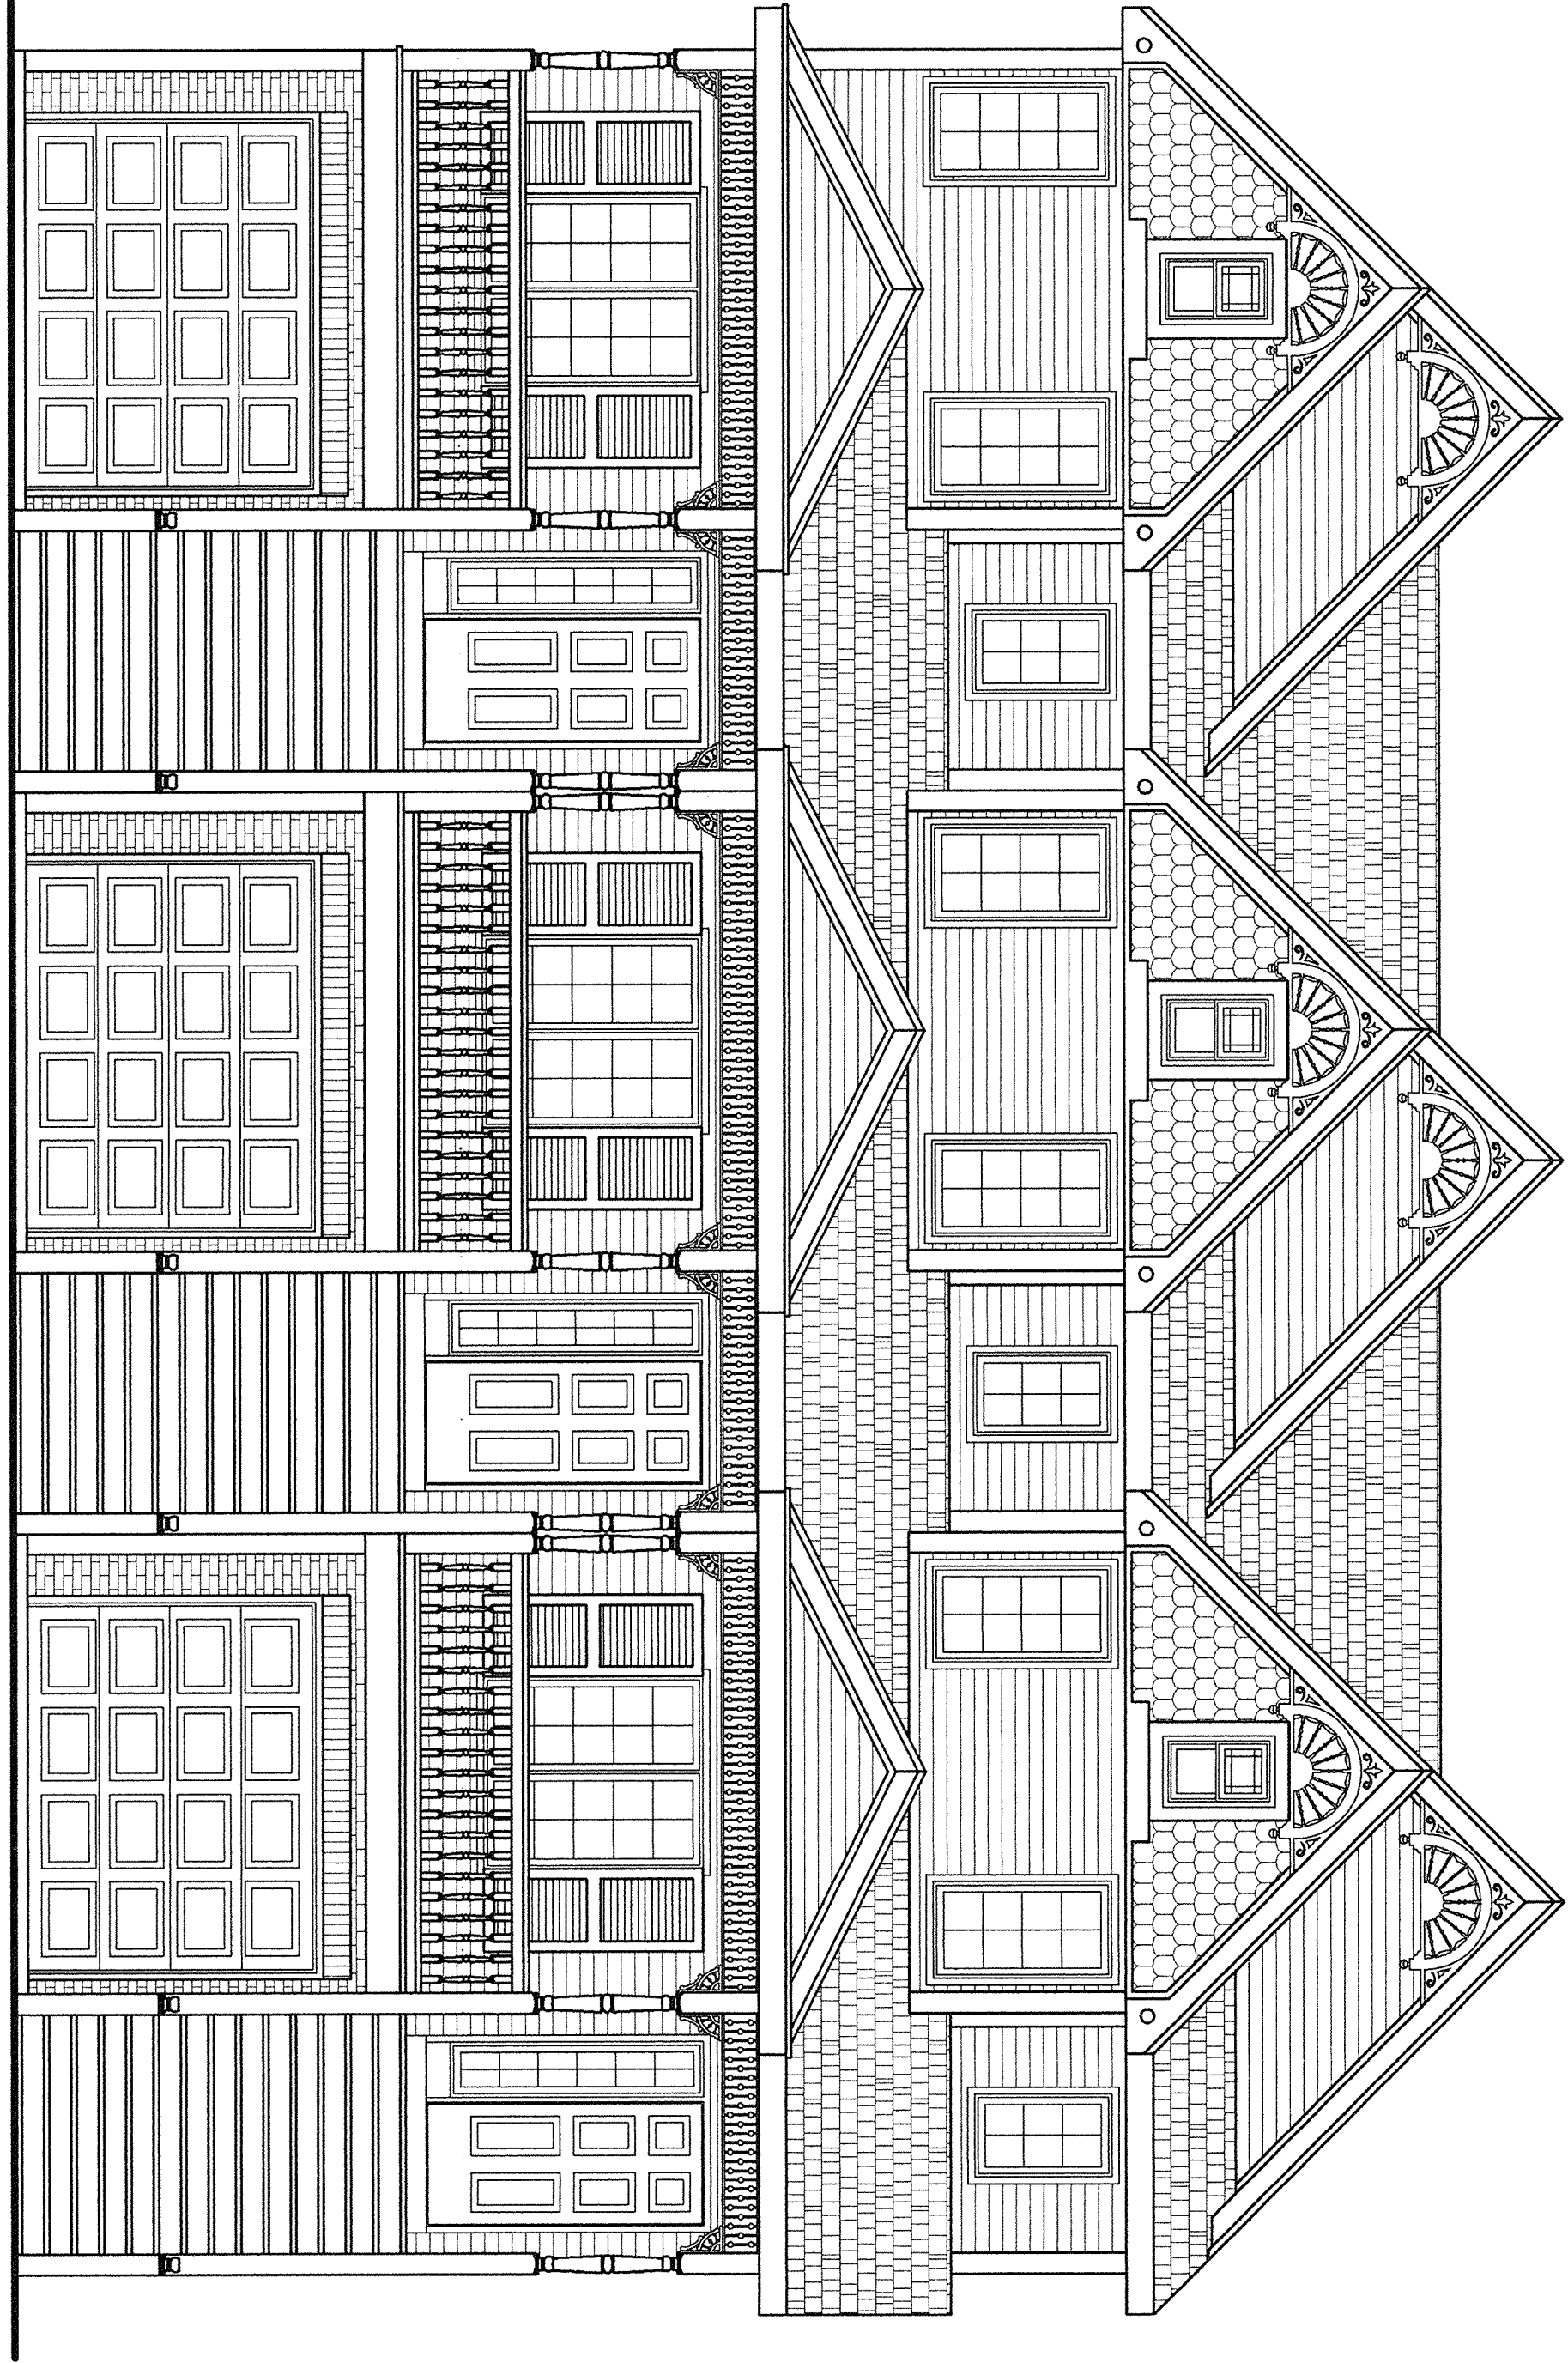

© design basics inc.

design basics inc.
HOME PLAN DESIGN SERVICE

ALL PLANS customizable

11112 John Galt Blvd. Omaha, NE 68137-2384
Fax: (402) 331-5507 Toll Free: (800) 947-7528
www.designbasics.com

RR REVERSE AVAILABLE

design basics inc.
HOME PLAN DESIGN SERVICE


DESIGN BASICS, INC. IS A PROFESSIONAL RESIDENTIAL DESIGN FIRM LOCATED IN OMAHA, NE. WE ARE A 100% EMPLOYED FIRM. WE DO NOT HIRE ANY OTHER FIRM TO ASSIST IN THE DESIGN OF THESE PLANS FOR USE ON YOUR SPECIFIC SITE. CONSTRUCTION FROM THESE PLANS SHOULD NOT BE UNDERTAKEN WITHOUT THE ASSISTANCE OF A CONSTRUCTION PROFESSIONAL. THE PURCHASER OF THESE PLANS IS GIVING A LIMITED WARRANTY TO THE DESIGNER. TO REPRODUCE THESE PLANS FOR CONSTRUCTION PURPOSES ONLY AND FURTHER DISTRIBUTION IS STRICTLY PROHIBITED.

© 2001


7228
SHEET 1 of 5




IF THIS IS NOT RED
DO NOT COPY

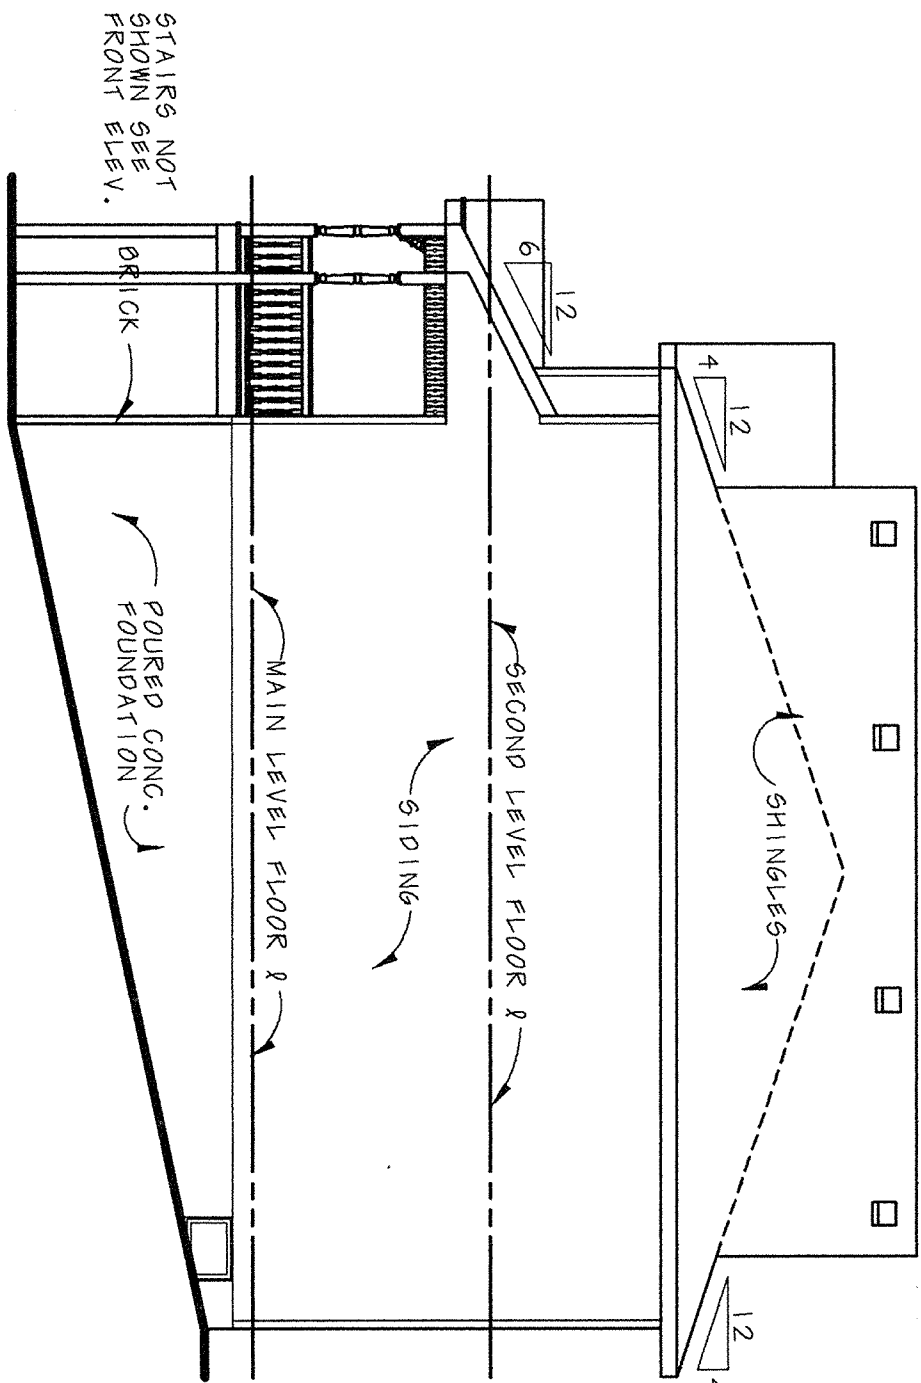


RIGHT SIDE ELEVATION
SCALE: 1/8" = 1'-0"

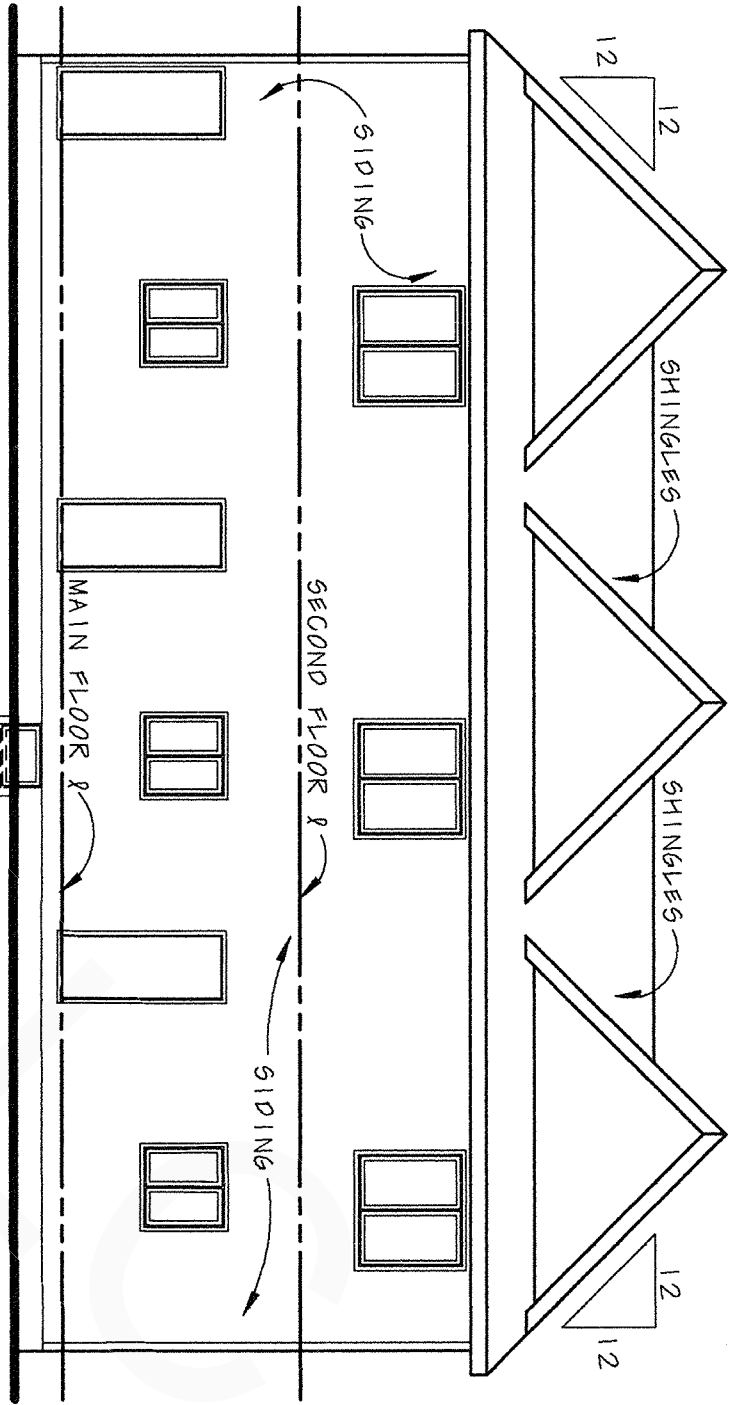


REAR ELEVATION
SCALE: 1/8" = 1'-0"

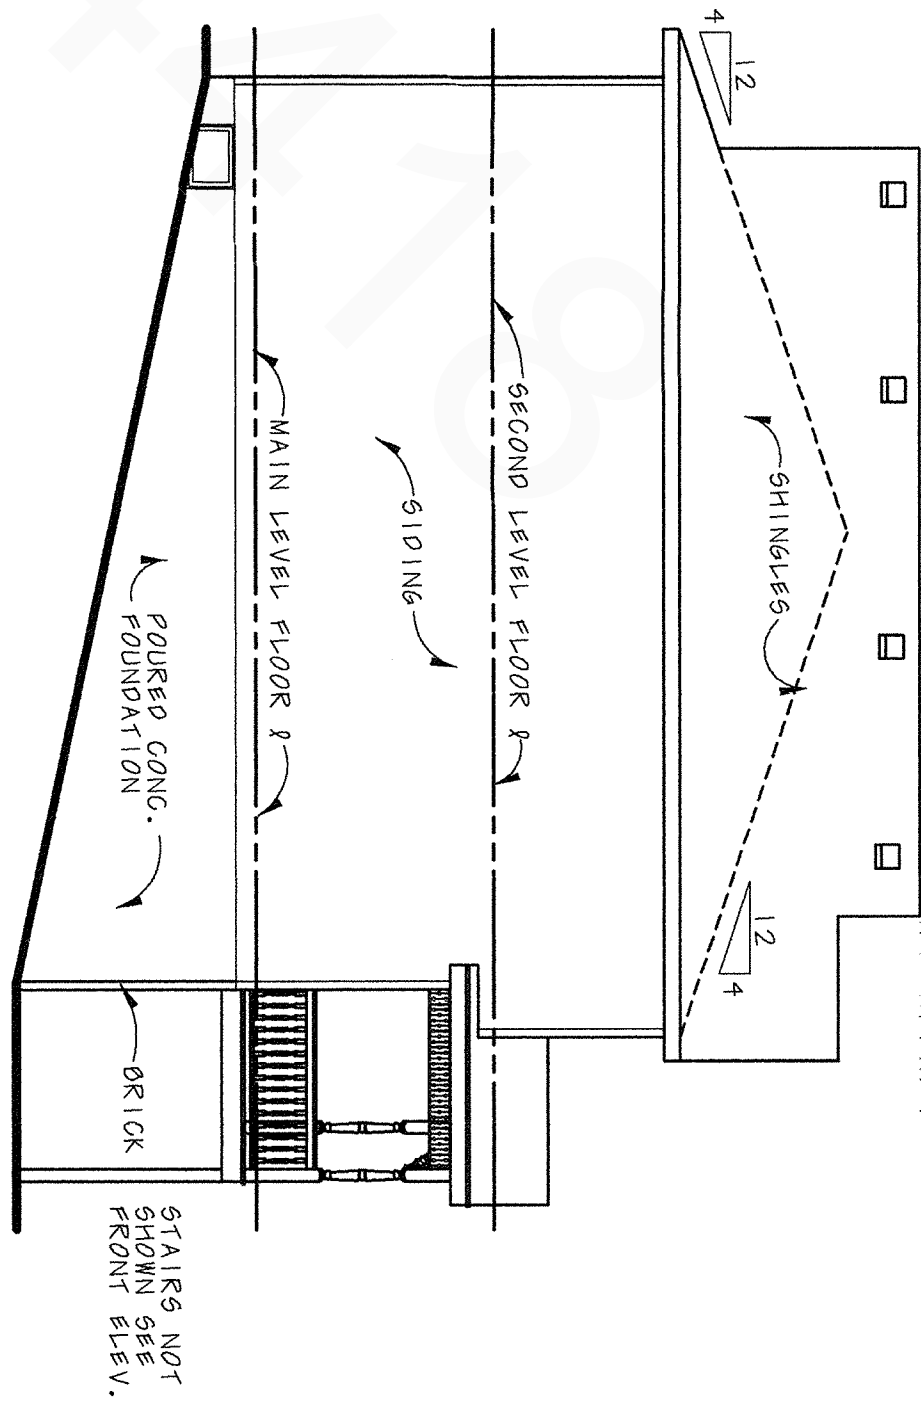



LEFT SIDE ELEVATION
SCALE: 1/8" = 1'-0"




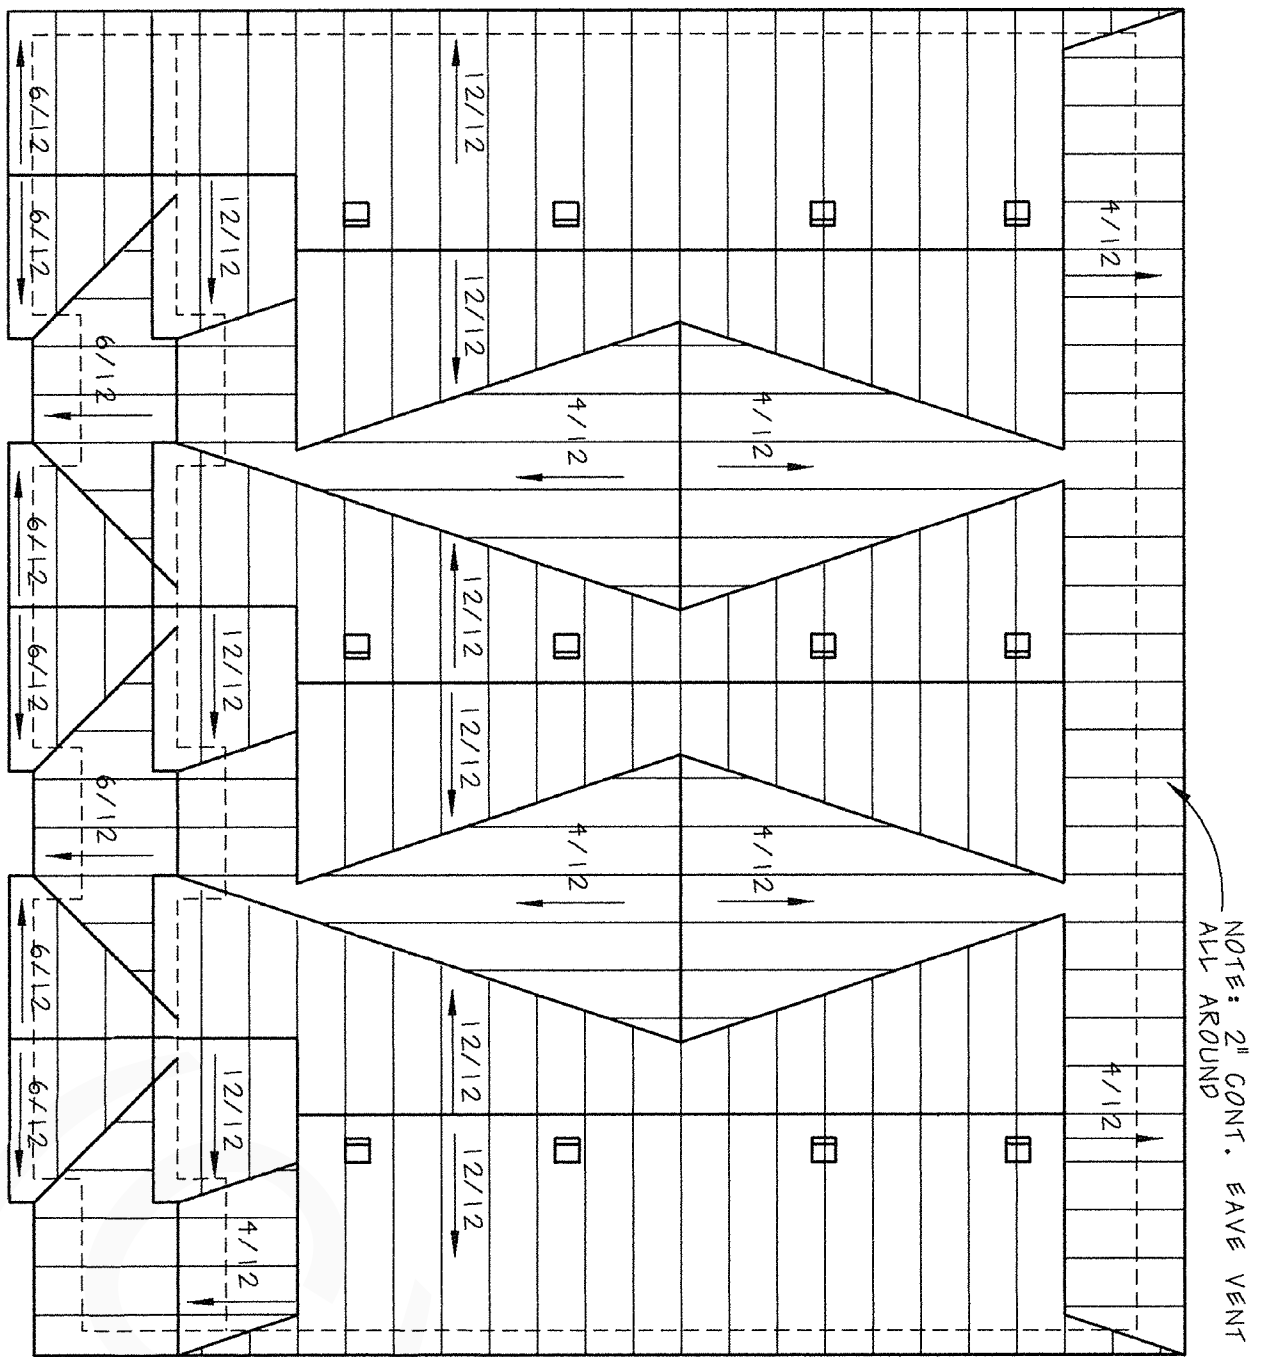


ROOF PLAN
SCALE: 1/8" = 1'-0"

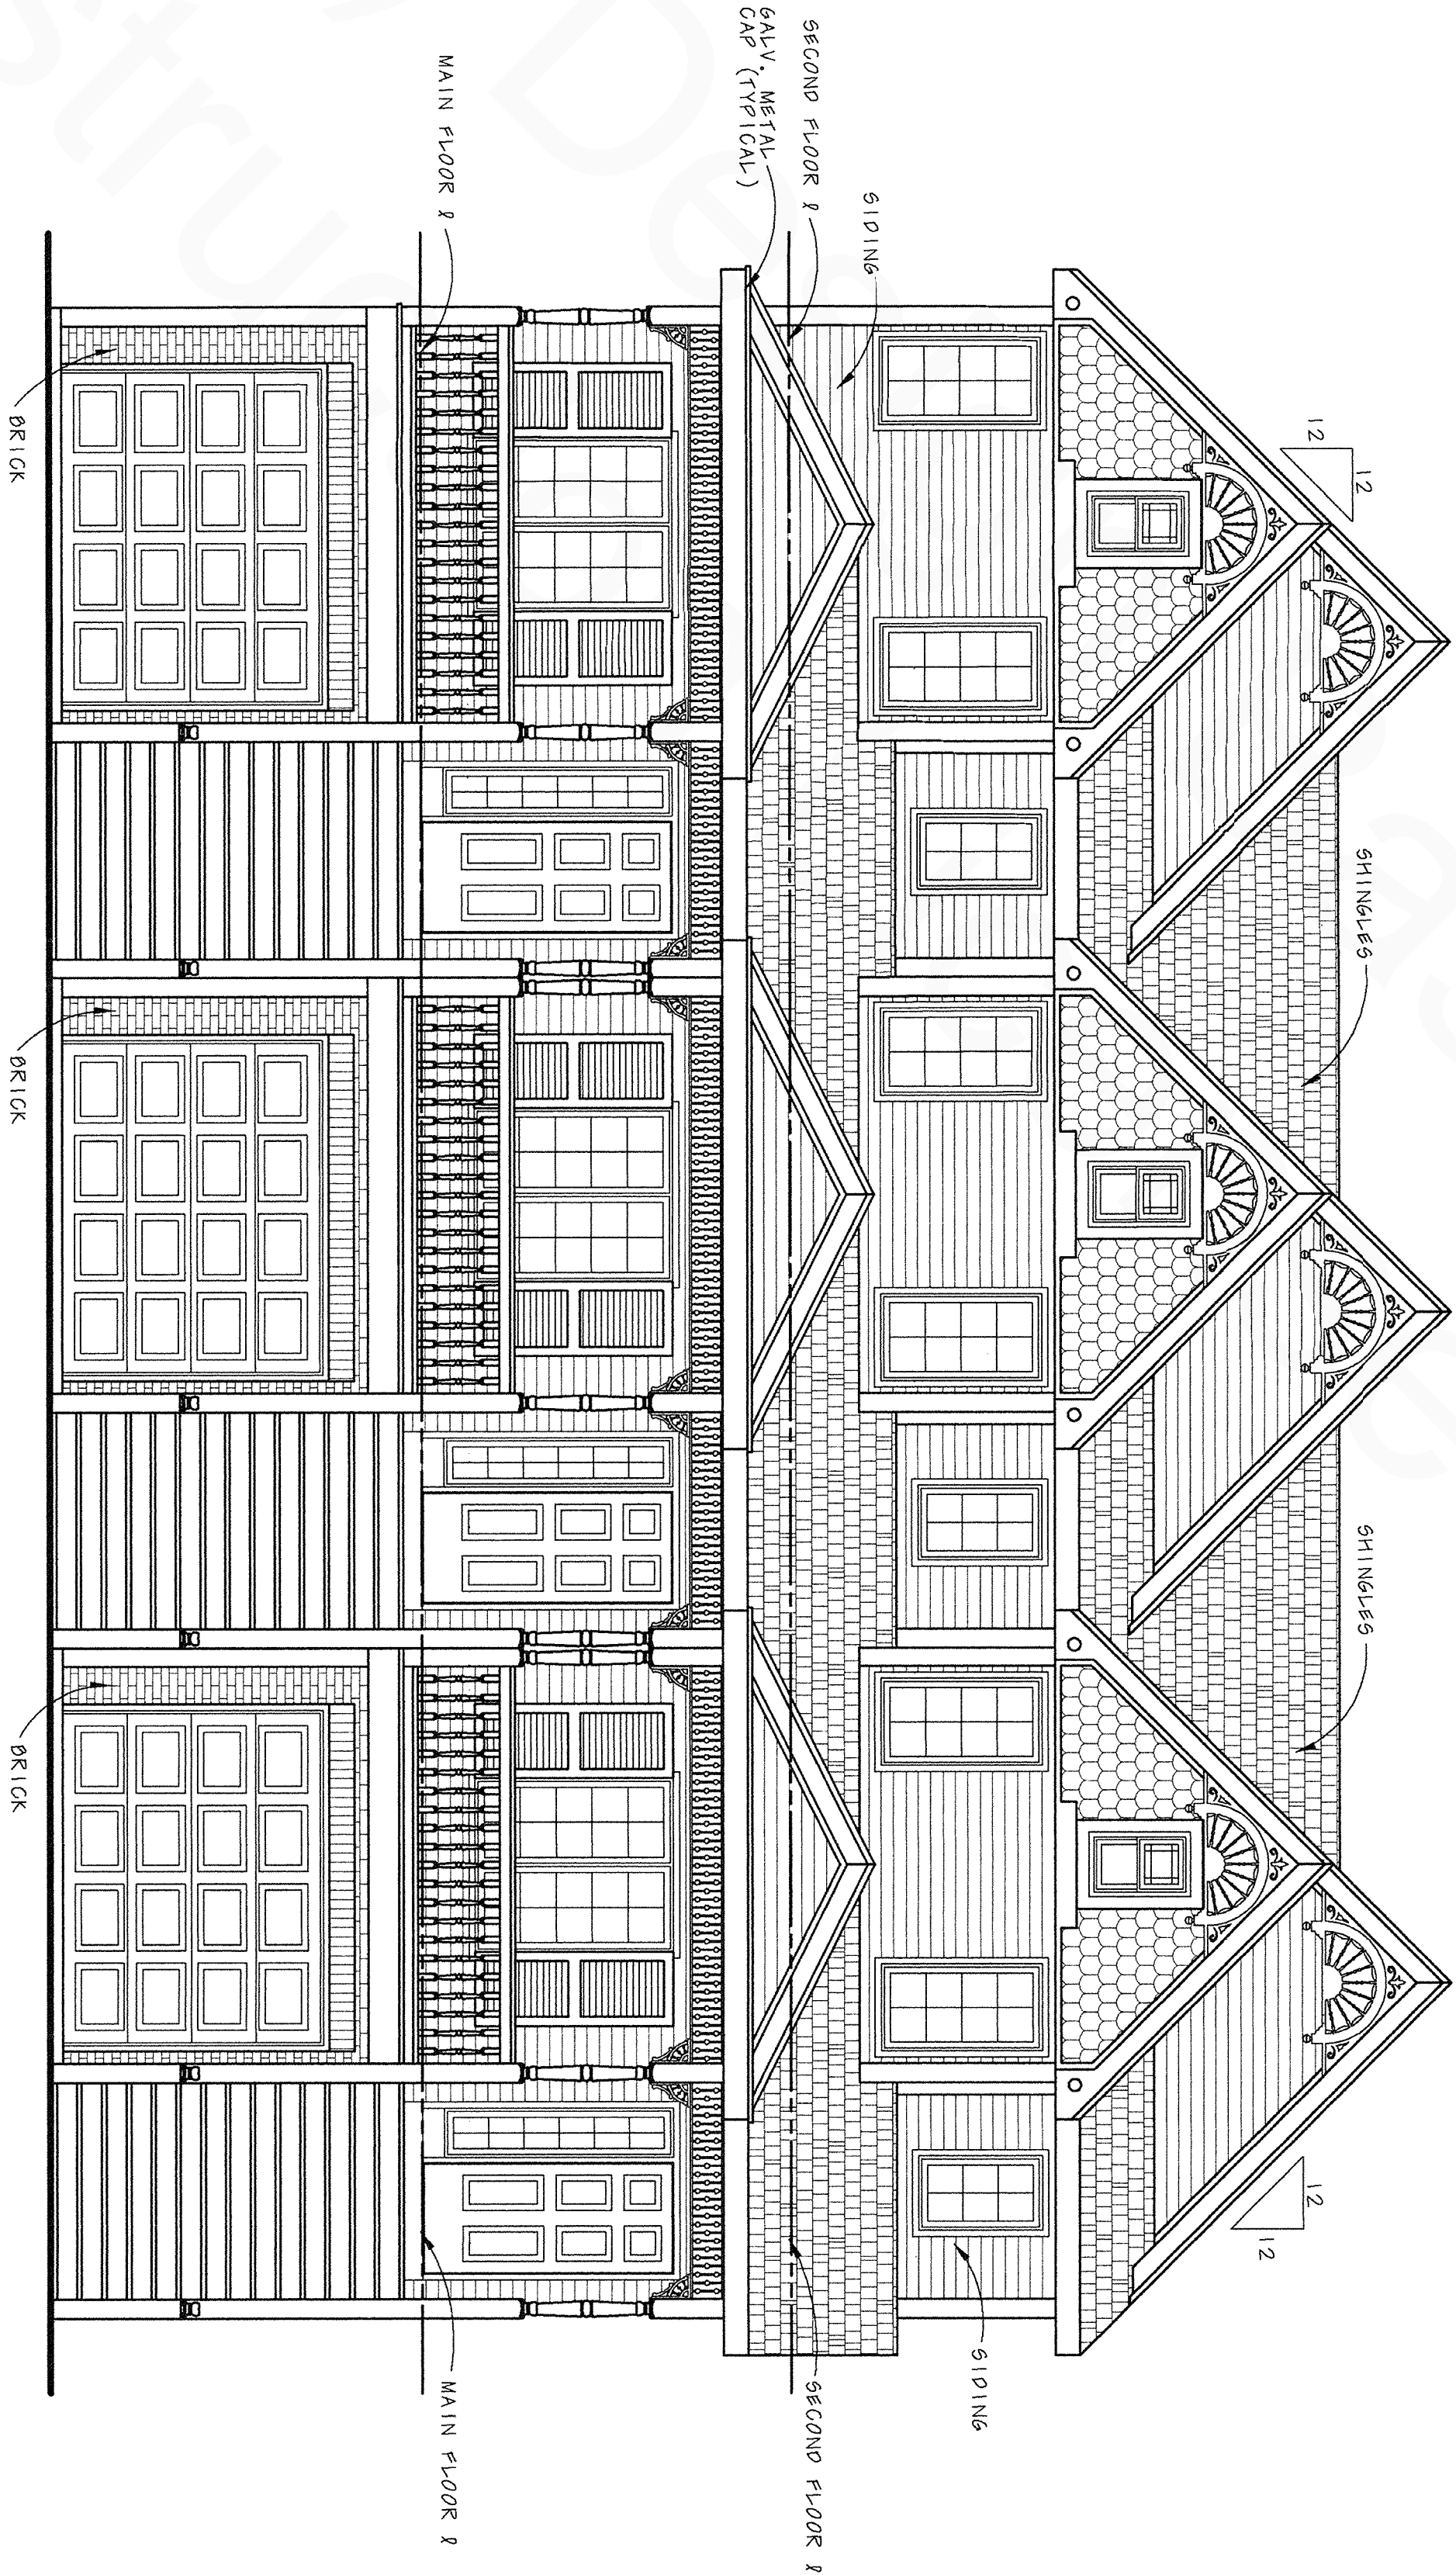

FRONT ELEVATION
SCALE: 1/4" = 1'-0"

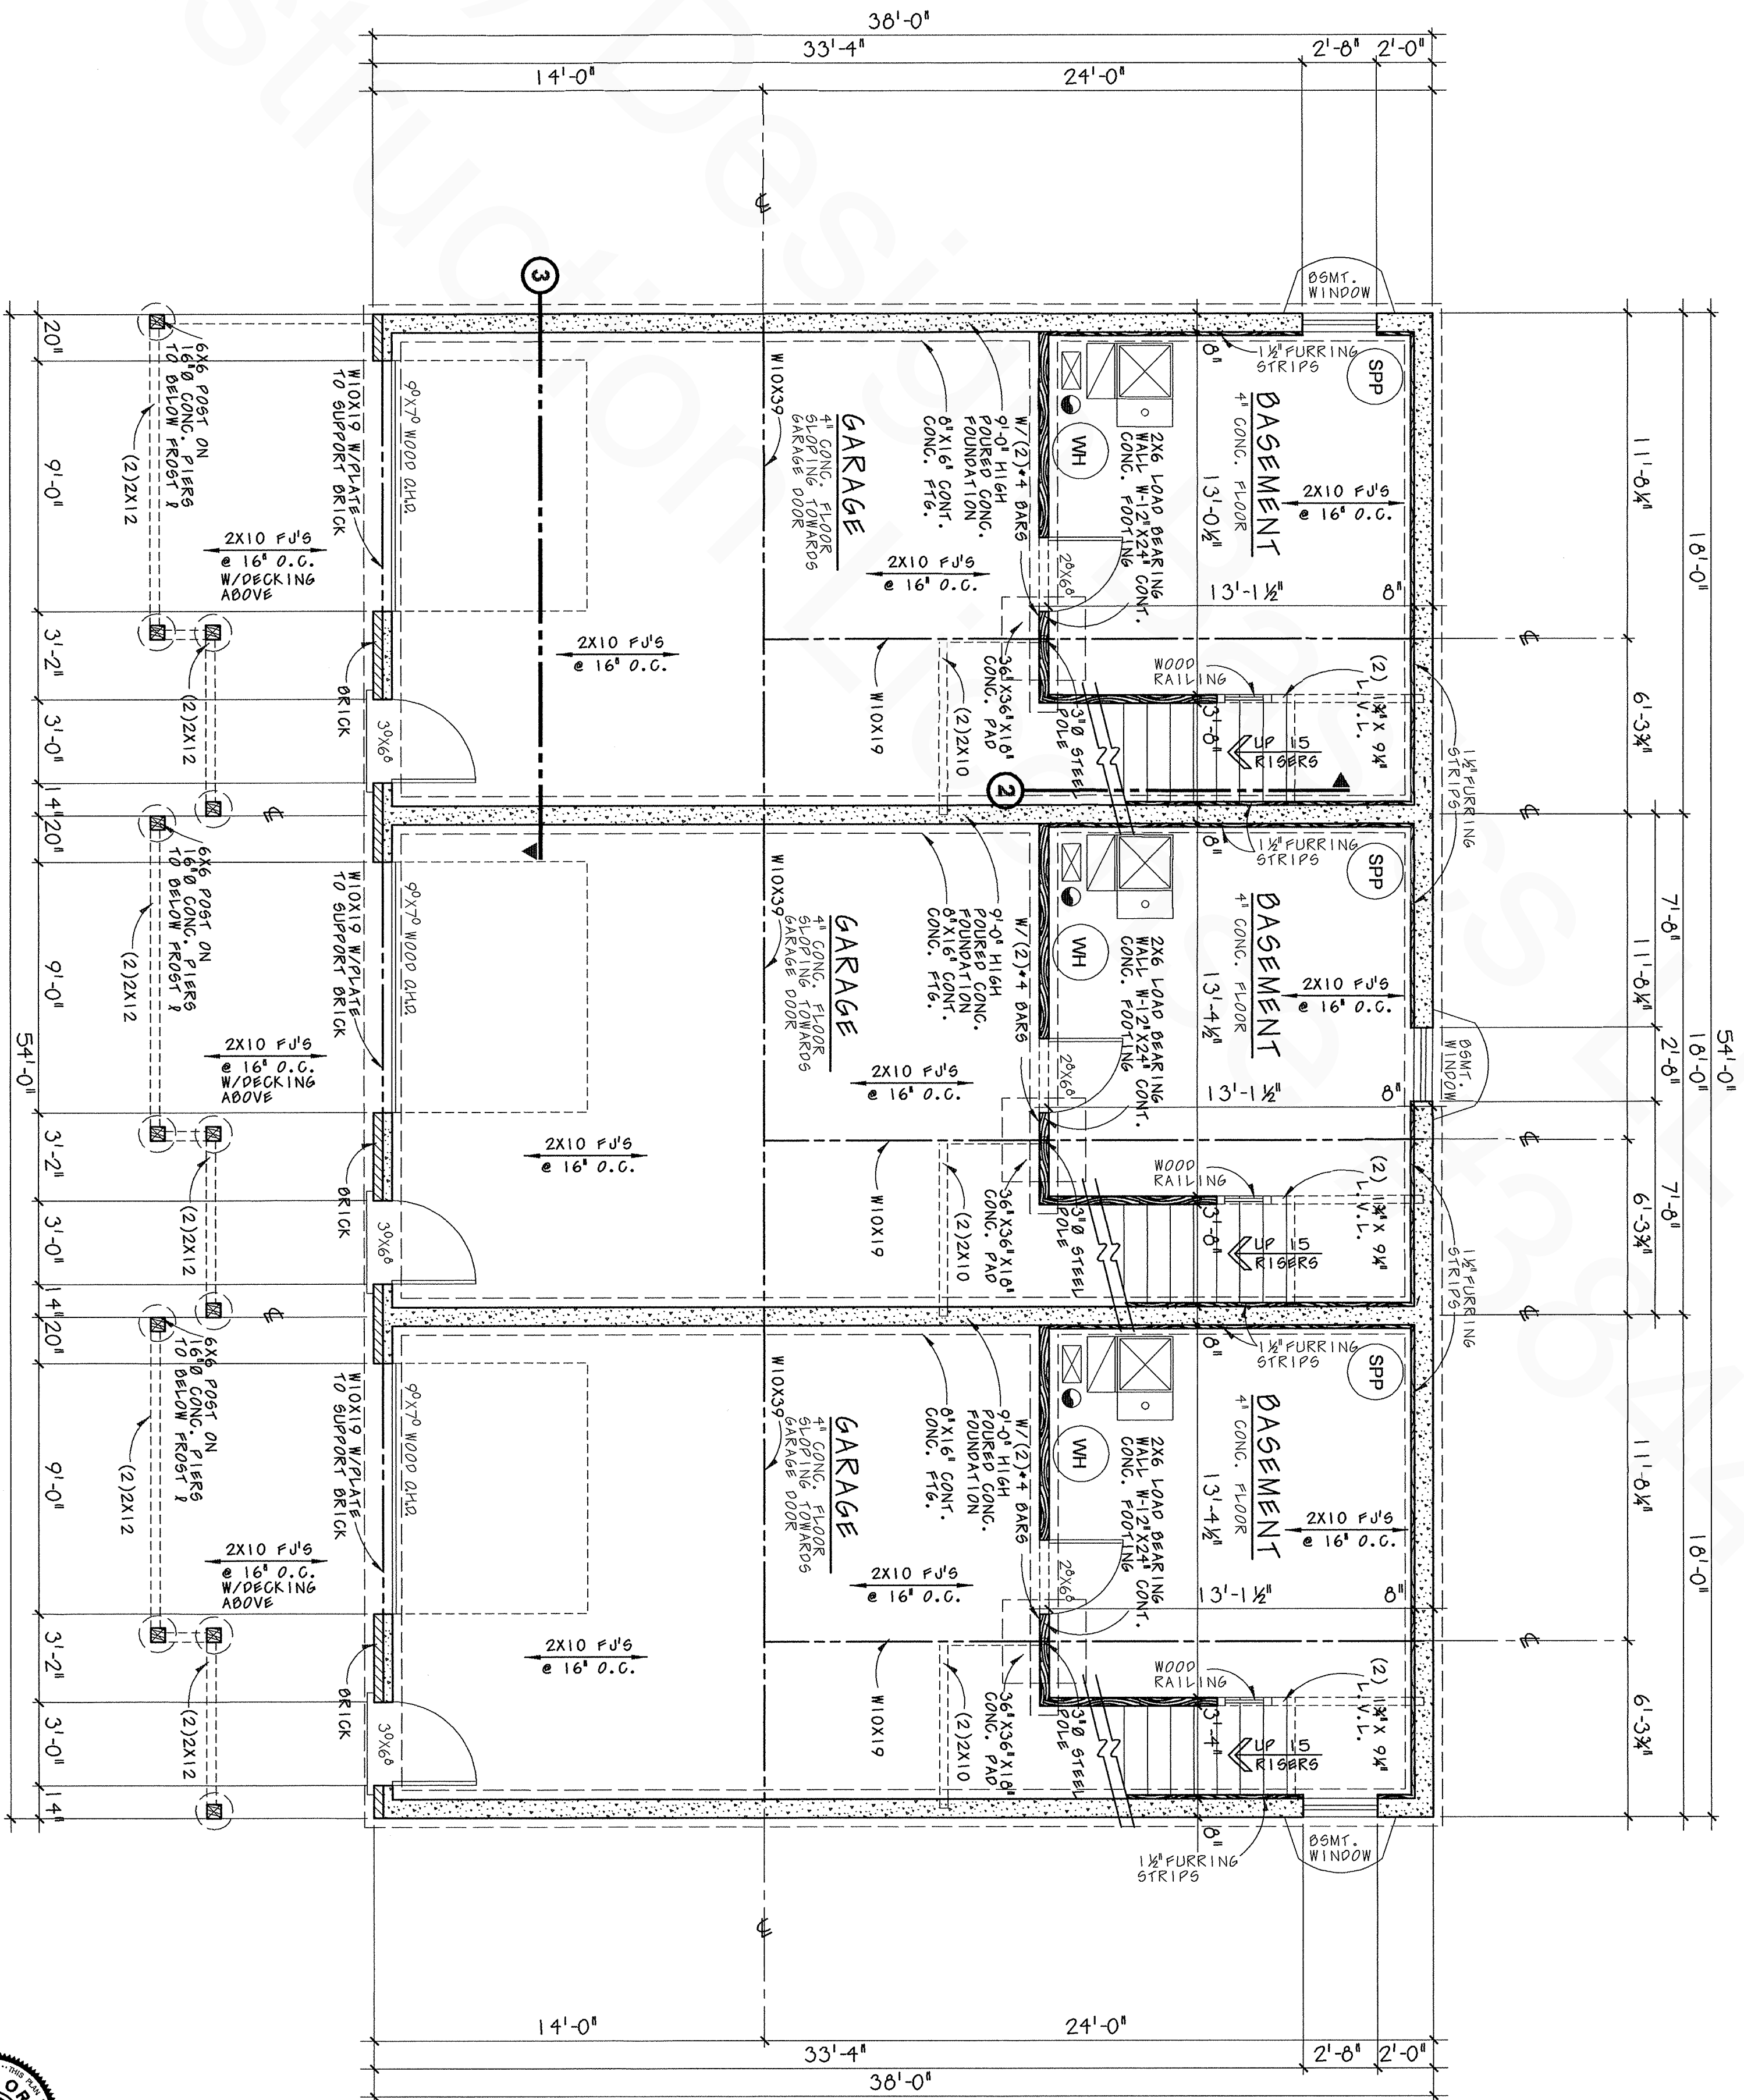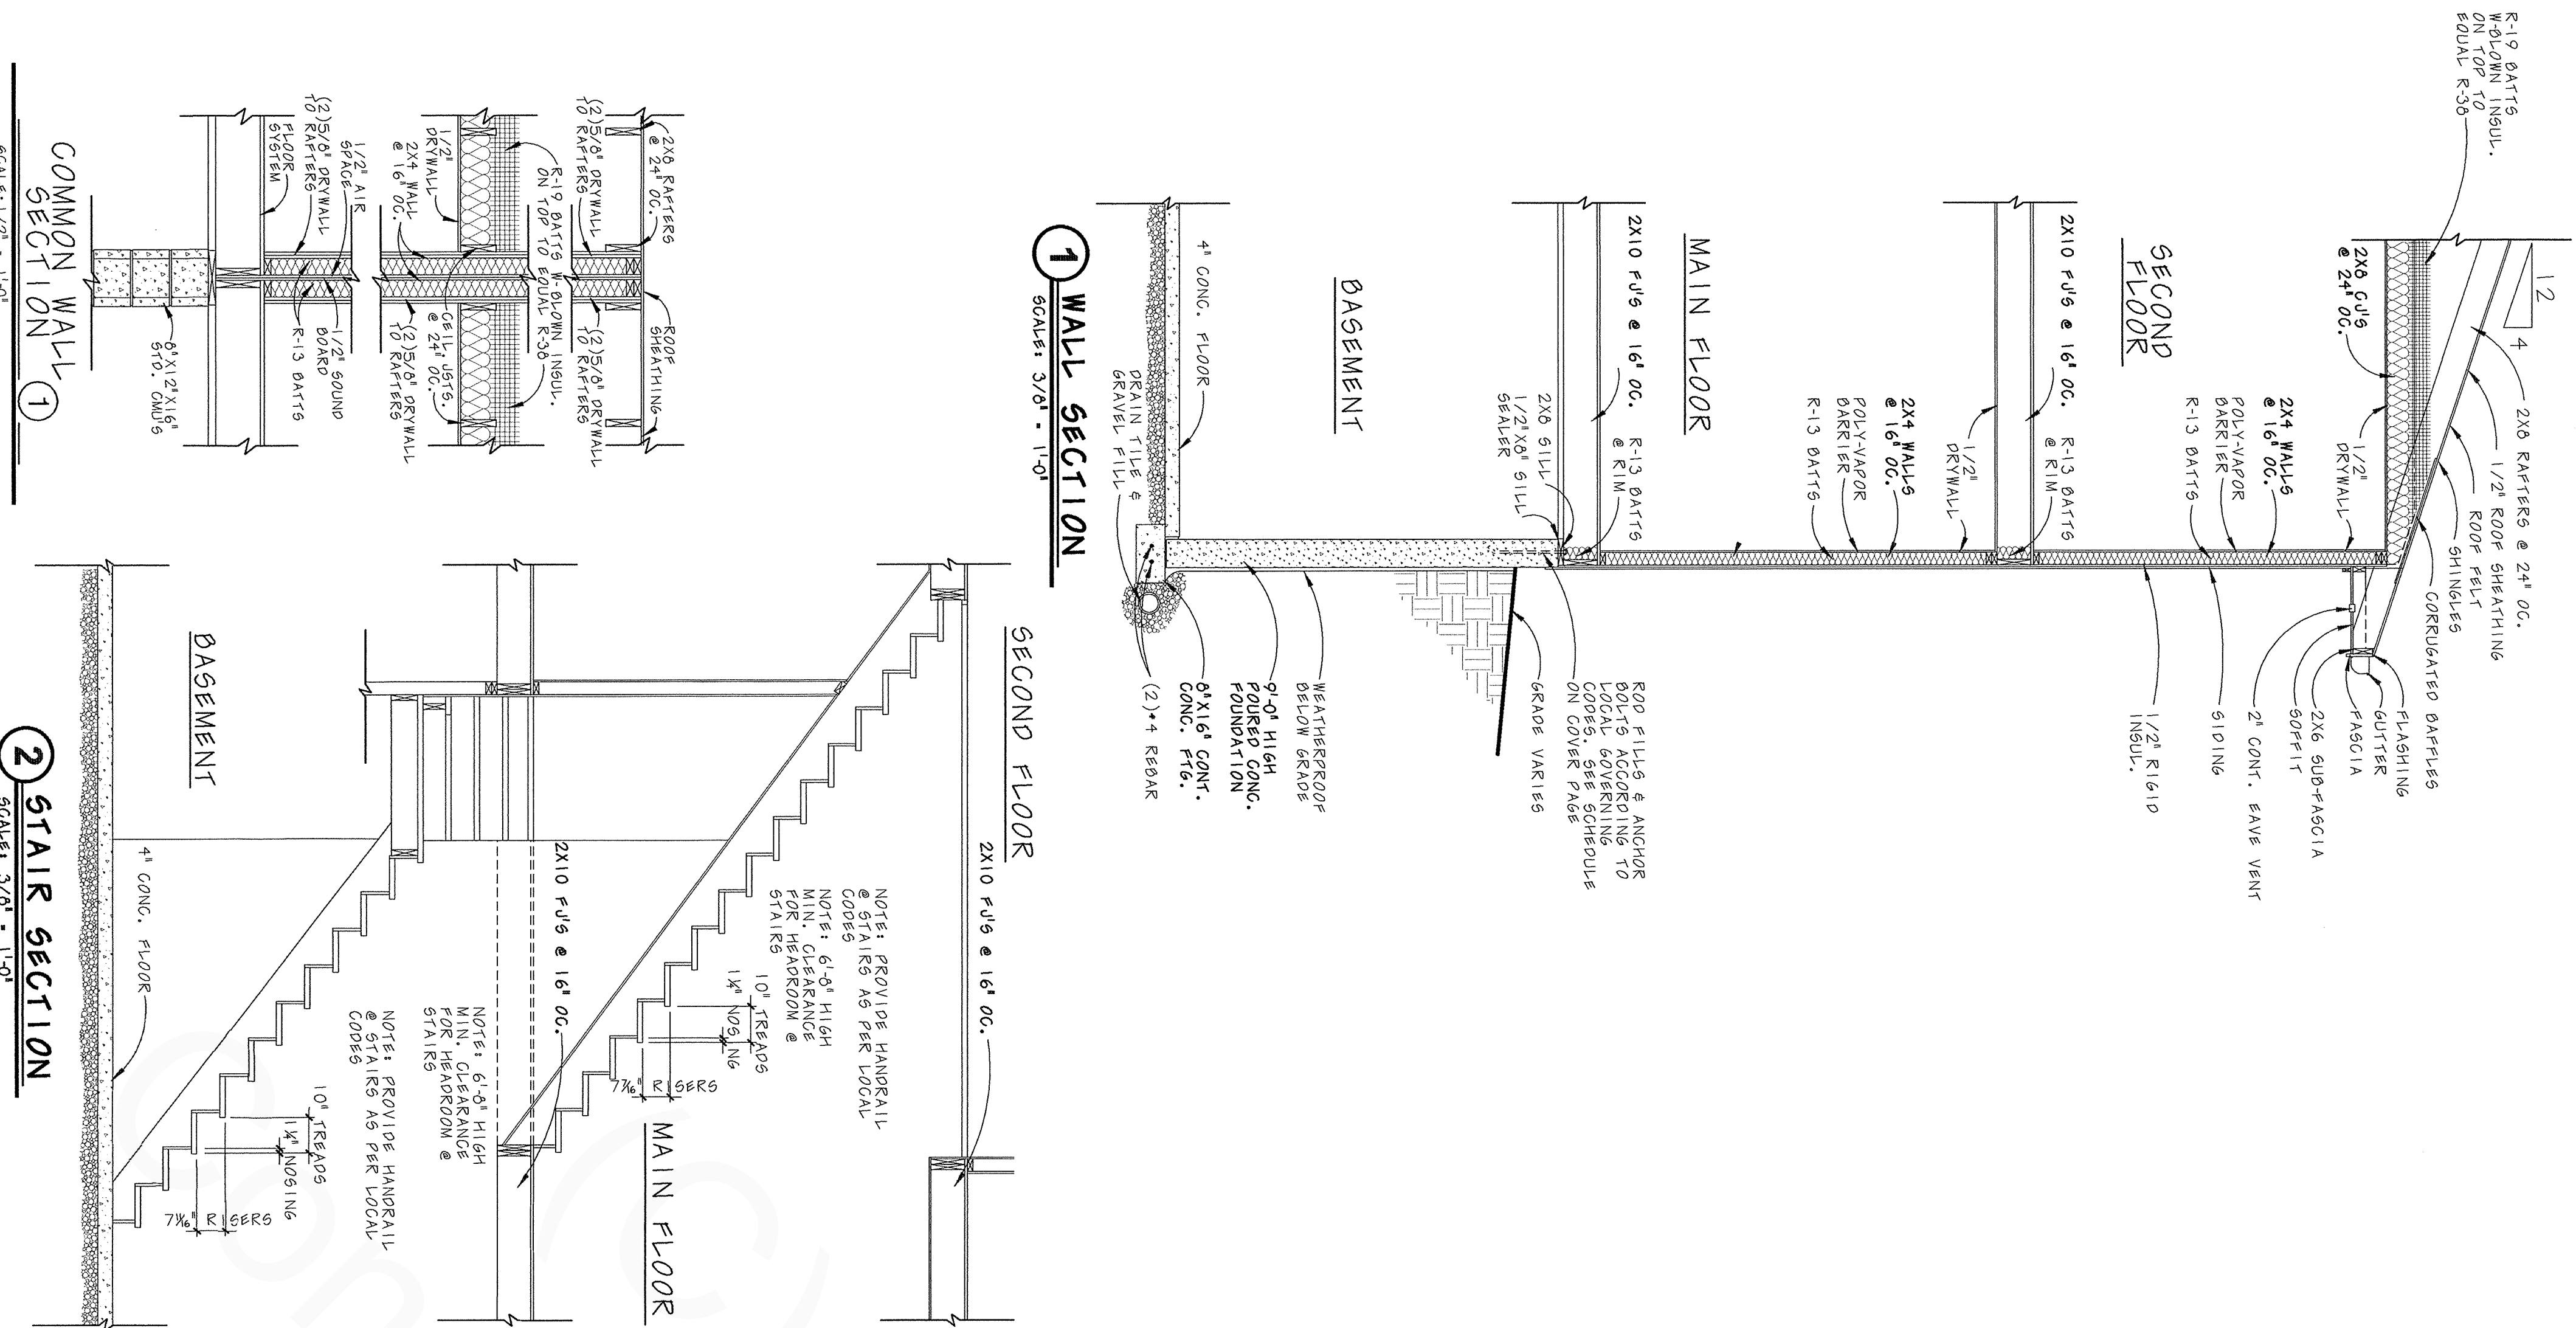

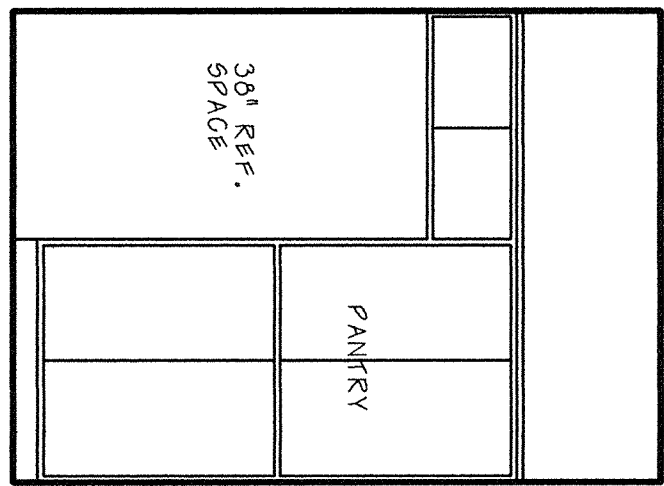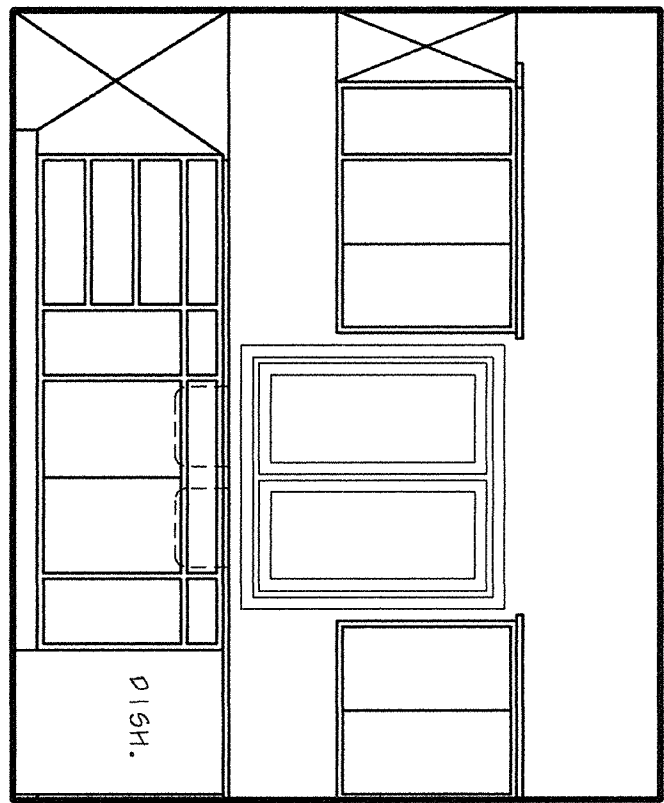
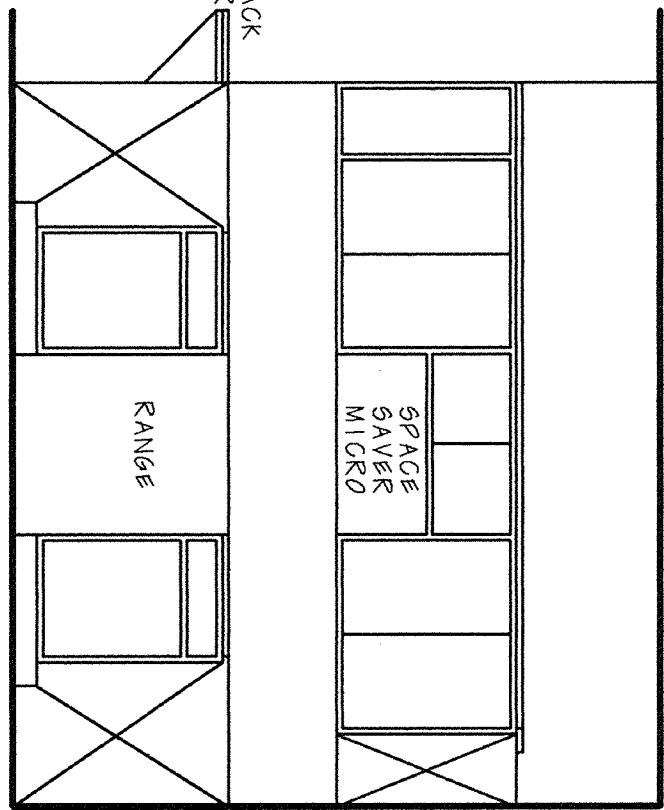
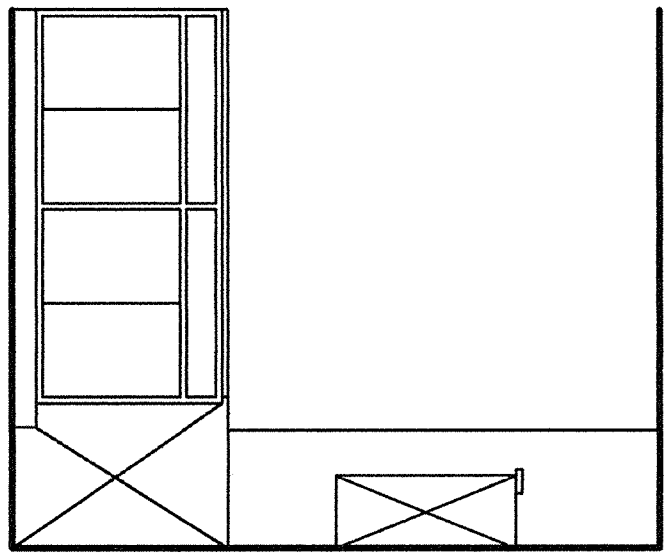


A KITCHEN

B KITCHEN

C KITCHEN



D KITCHEN

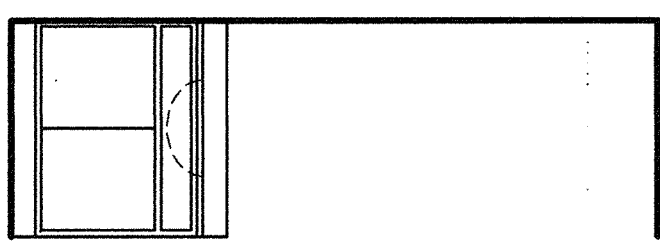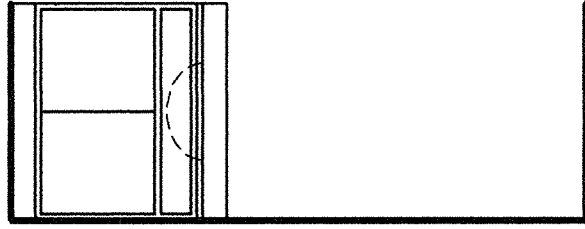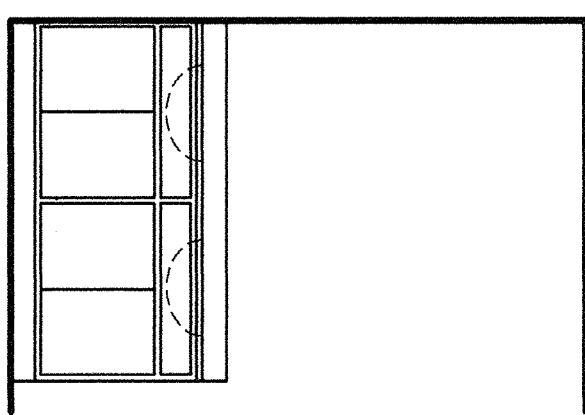

E BATH


F BATH

G BATH

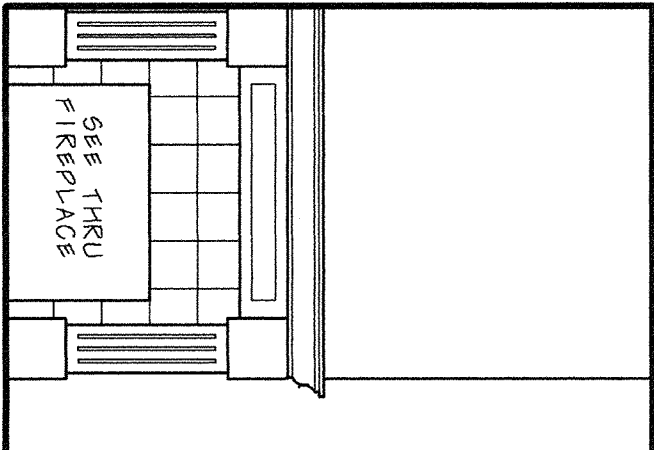
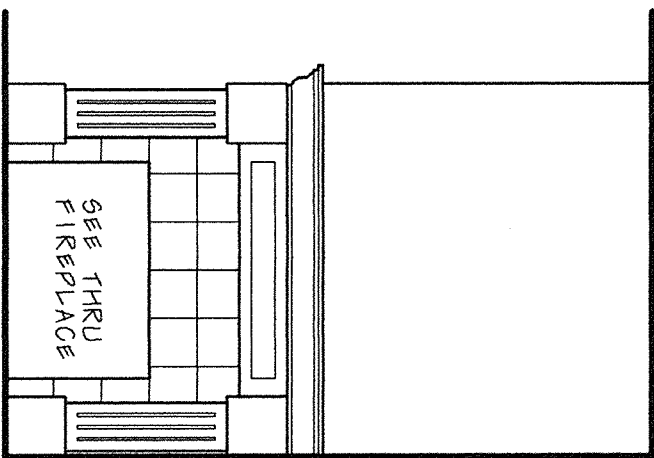


H FIREPLACE

J FIREPLACE

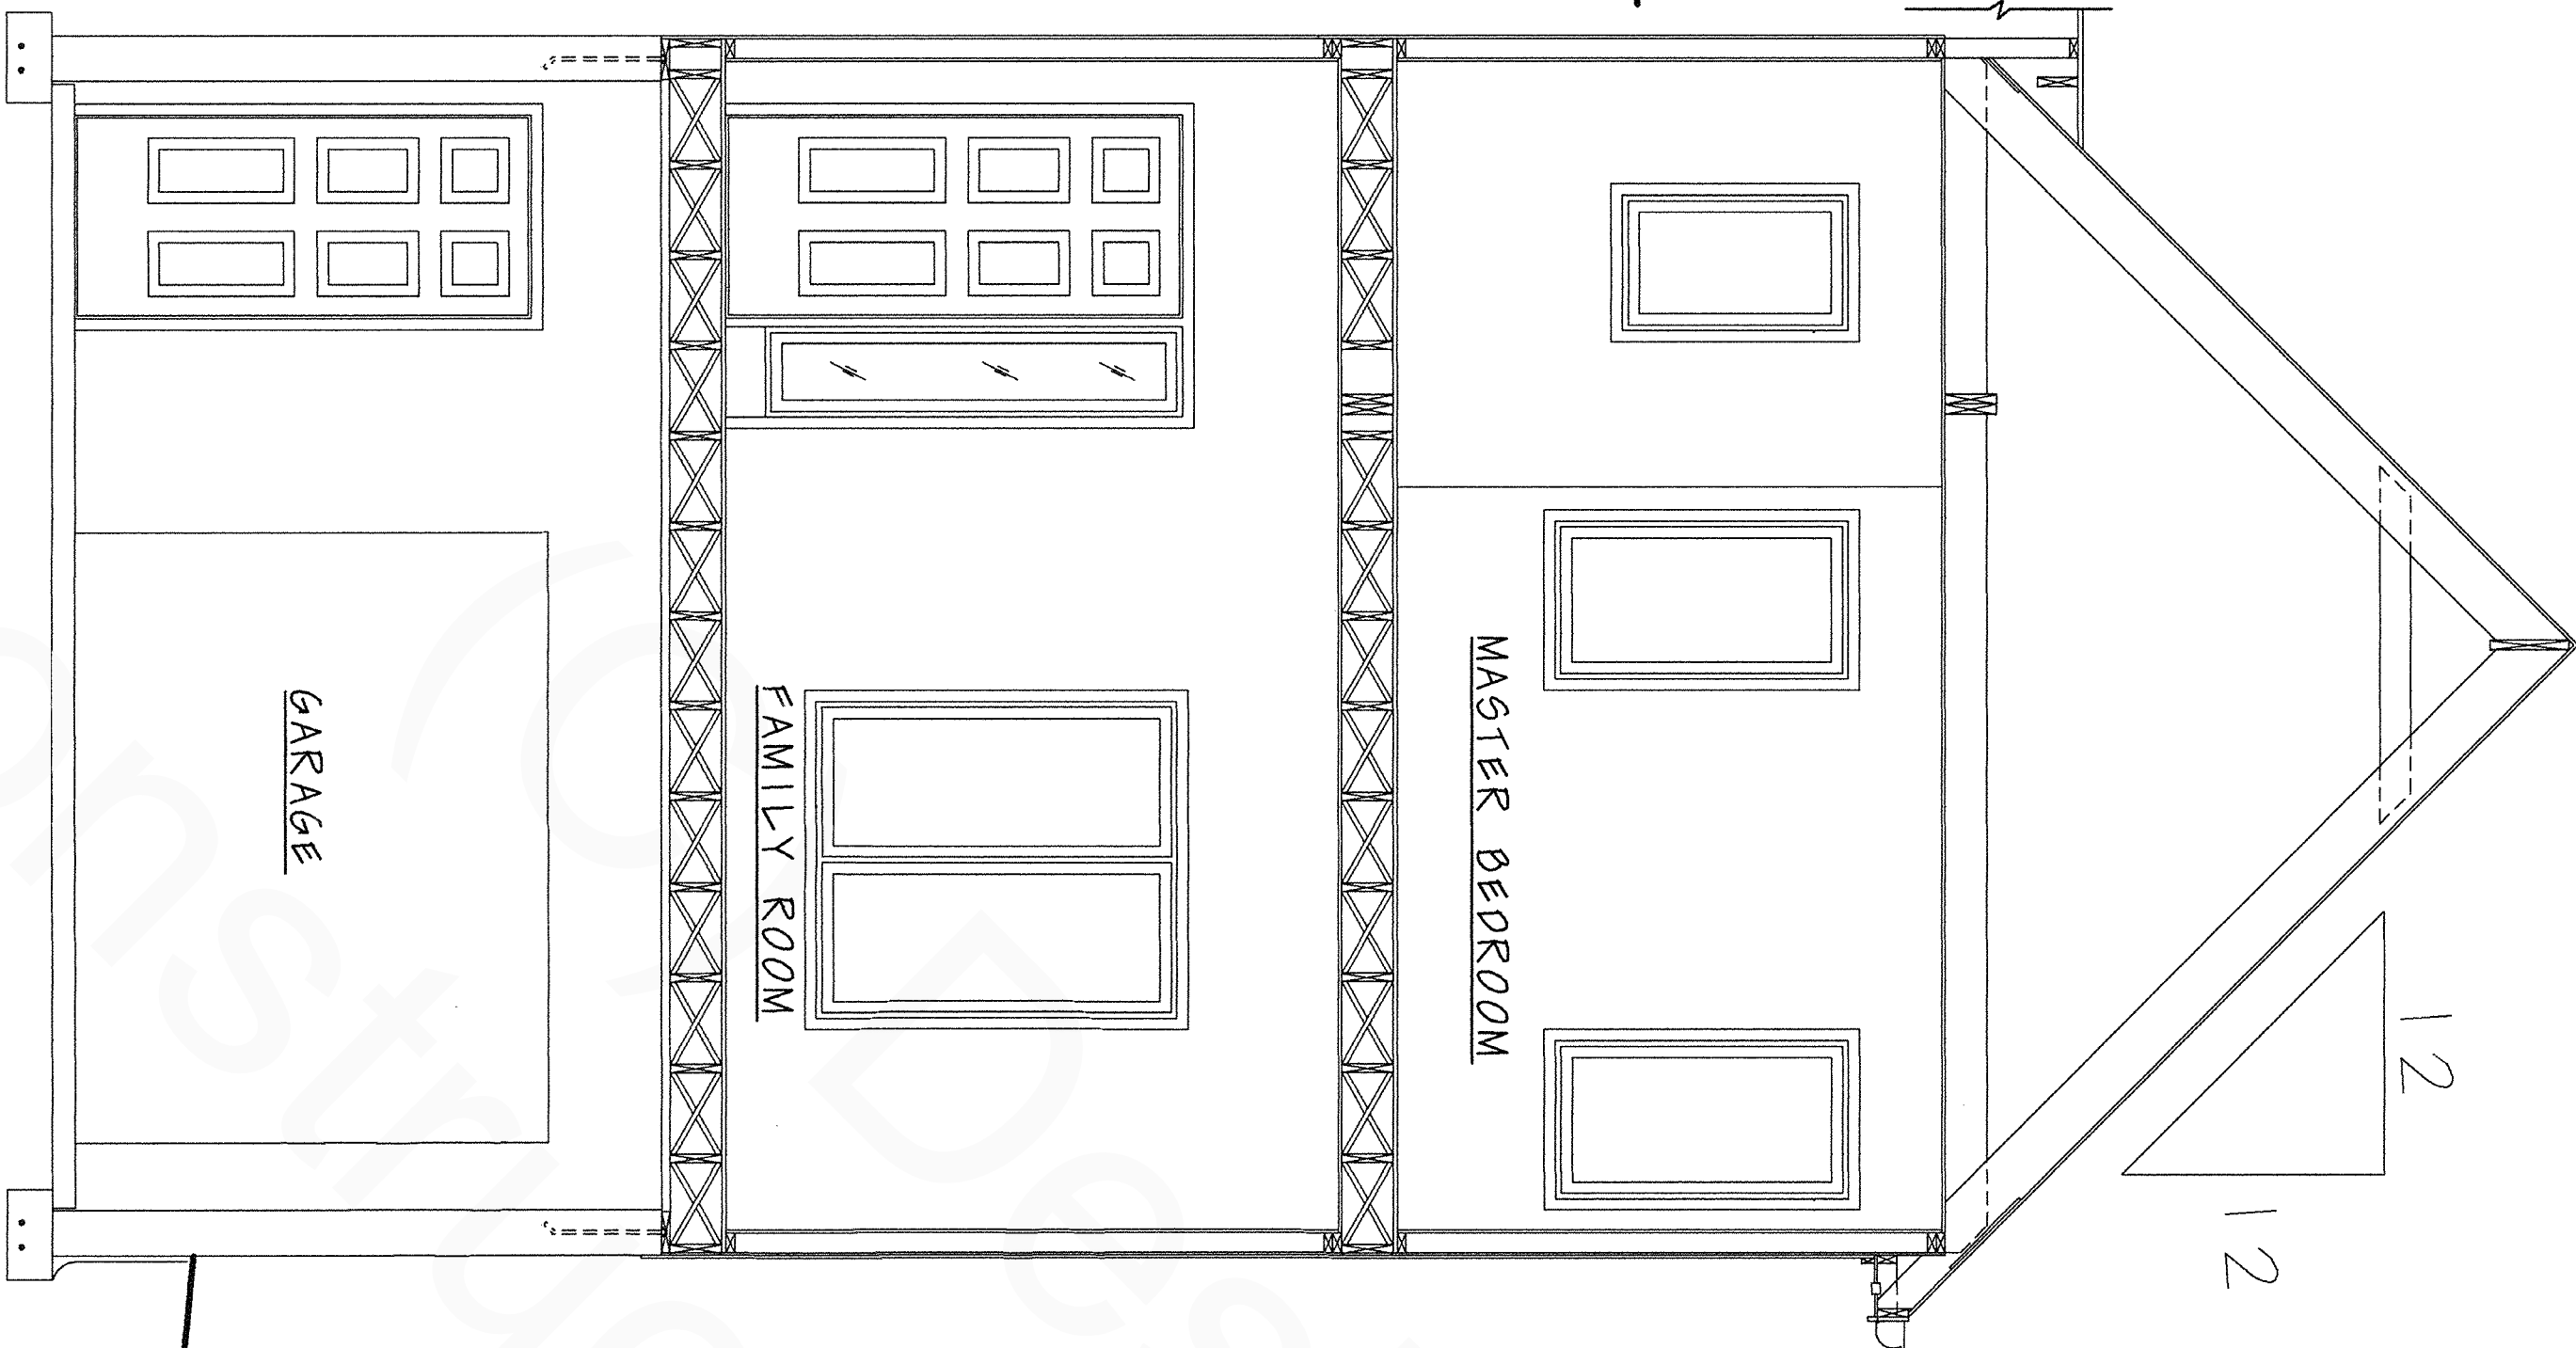

3 OVERALL SECTION
SCALE: 3/8" = 1'-0"

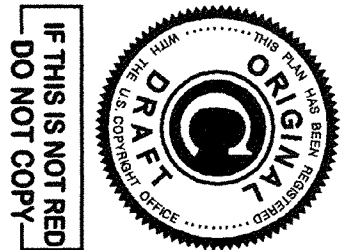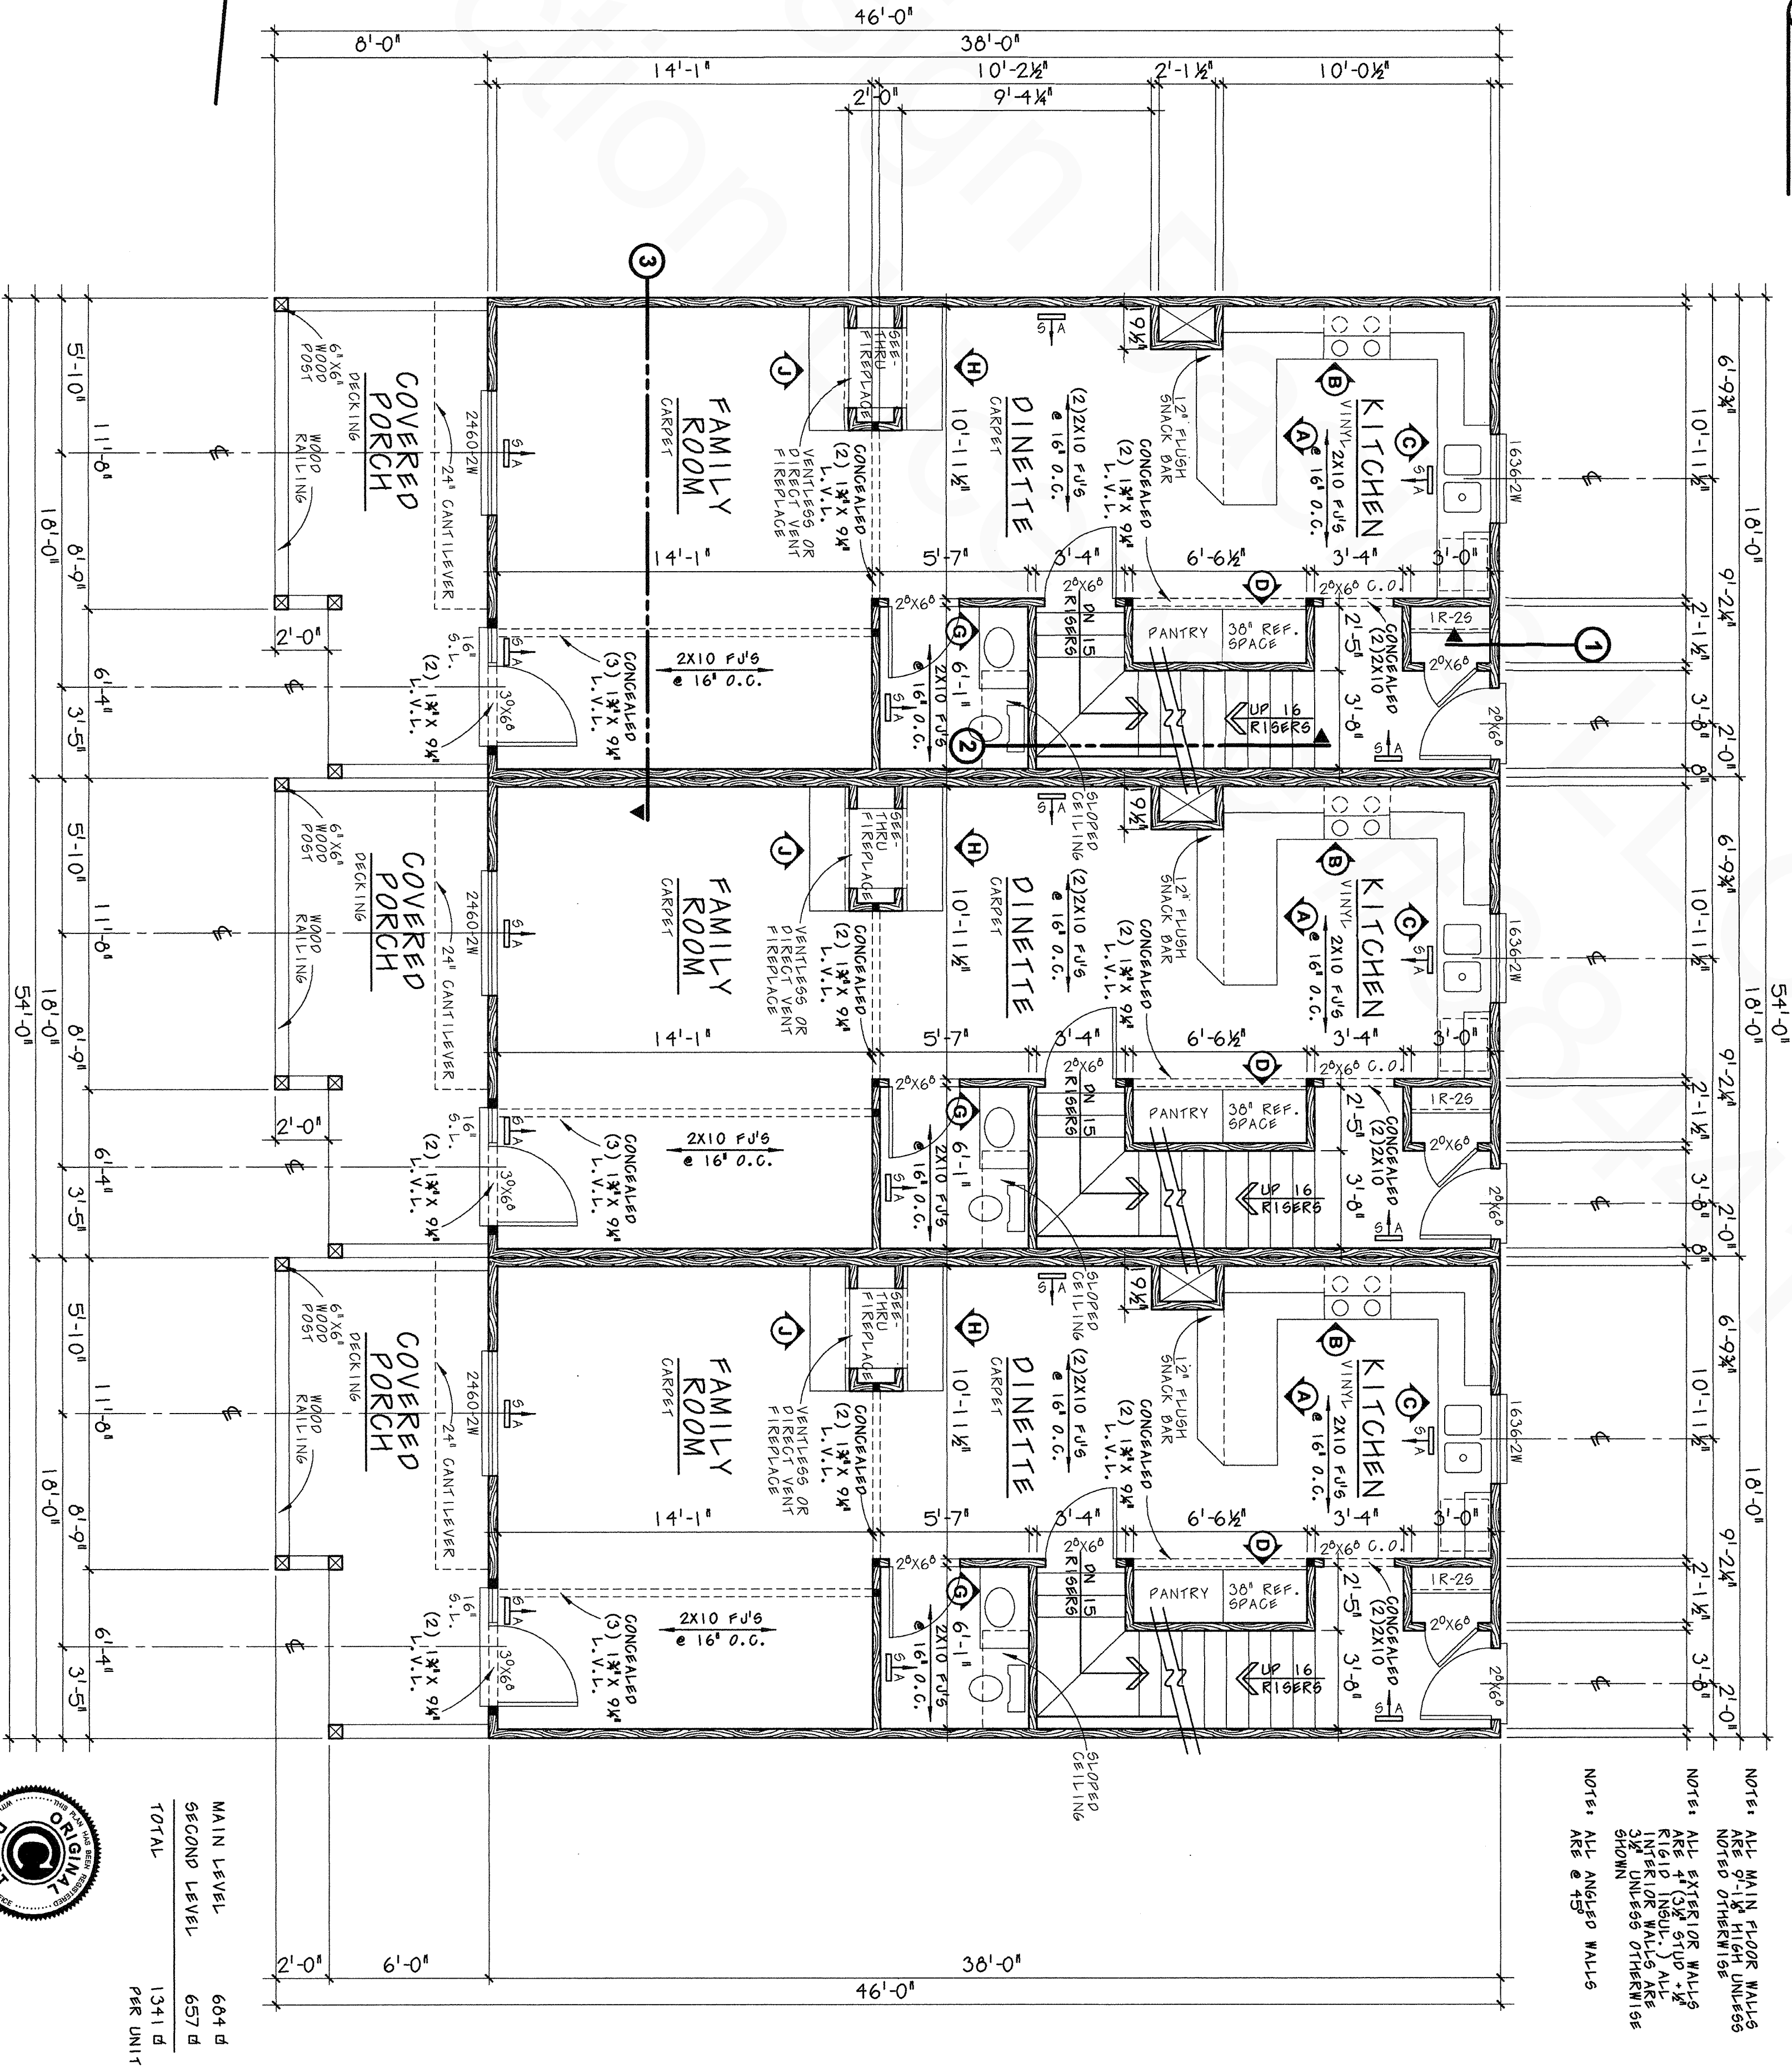

IF THIS IS NOT RED
DO NOT COPY


7228

Design Basics, Inc.
HOME PLAN DESIGN SERVICE

REVERSE
AVAILABLE


11112 John Galt Blvd. Omaha, NE 68137-2384
Fax: (402) 331-5507 Toll Free: (800) 847-7526
www.designbasics.com

ALL
PLANS
customizable

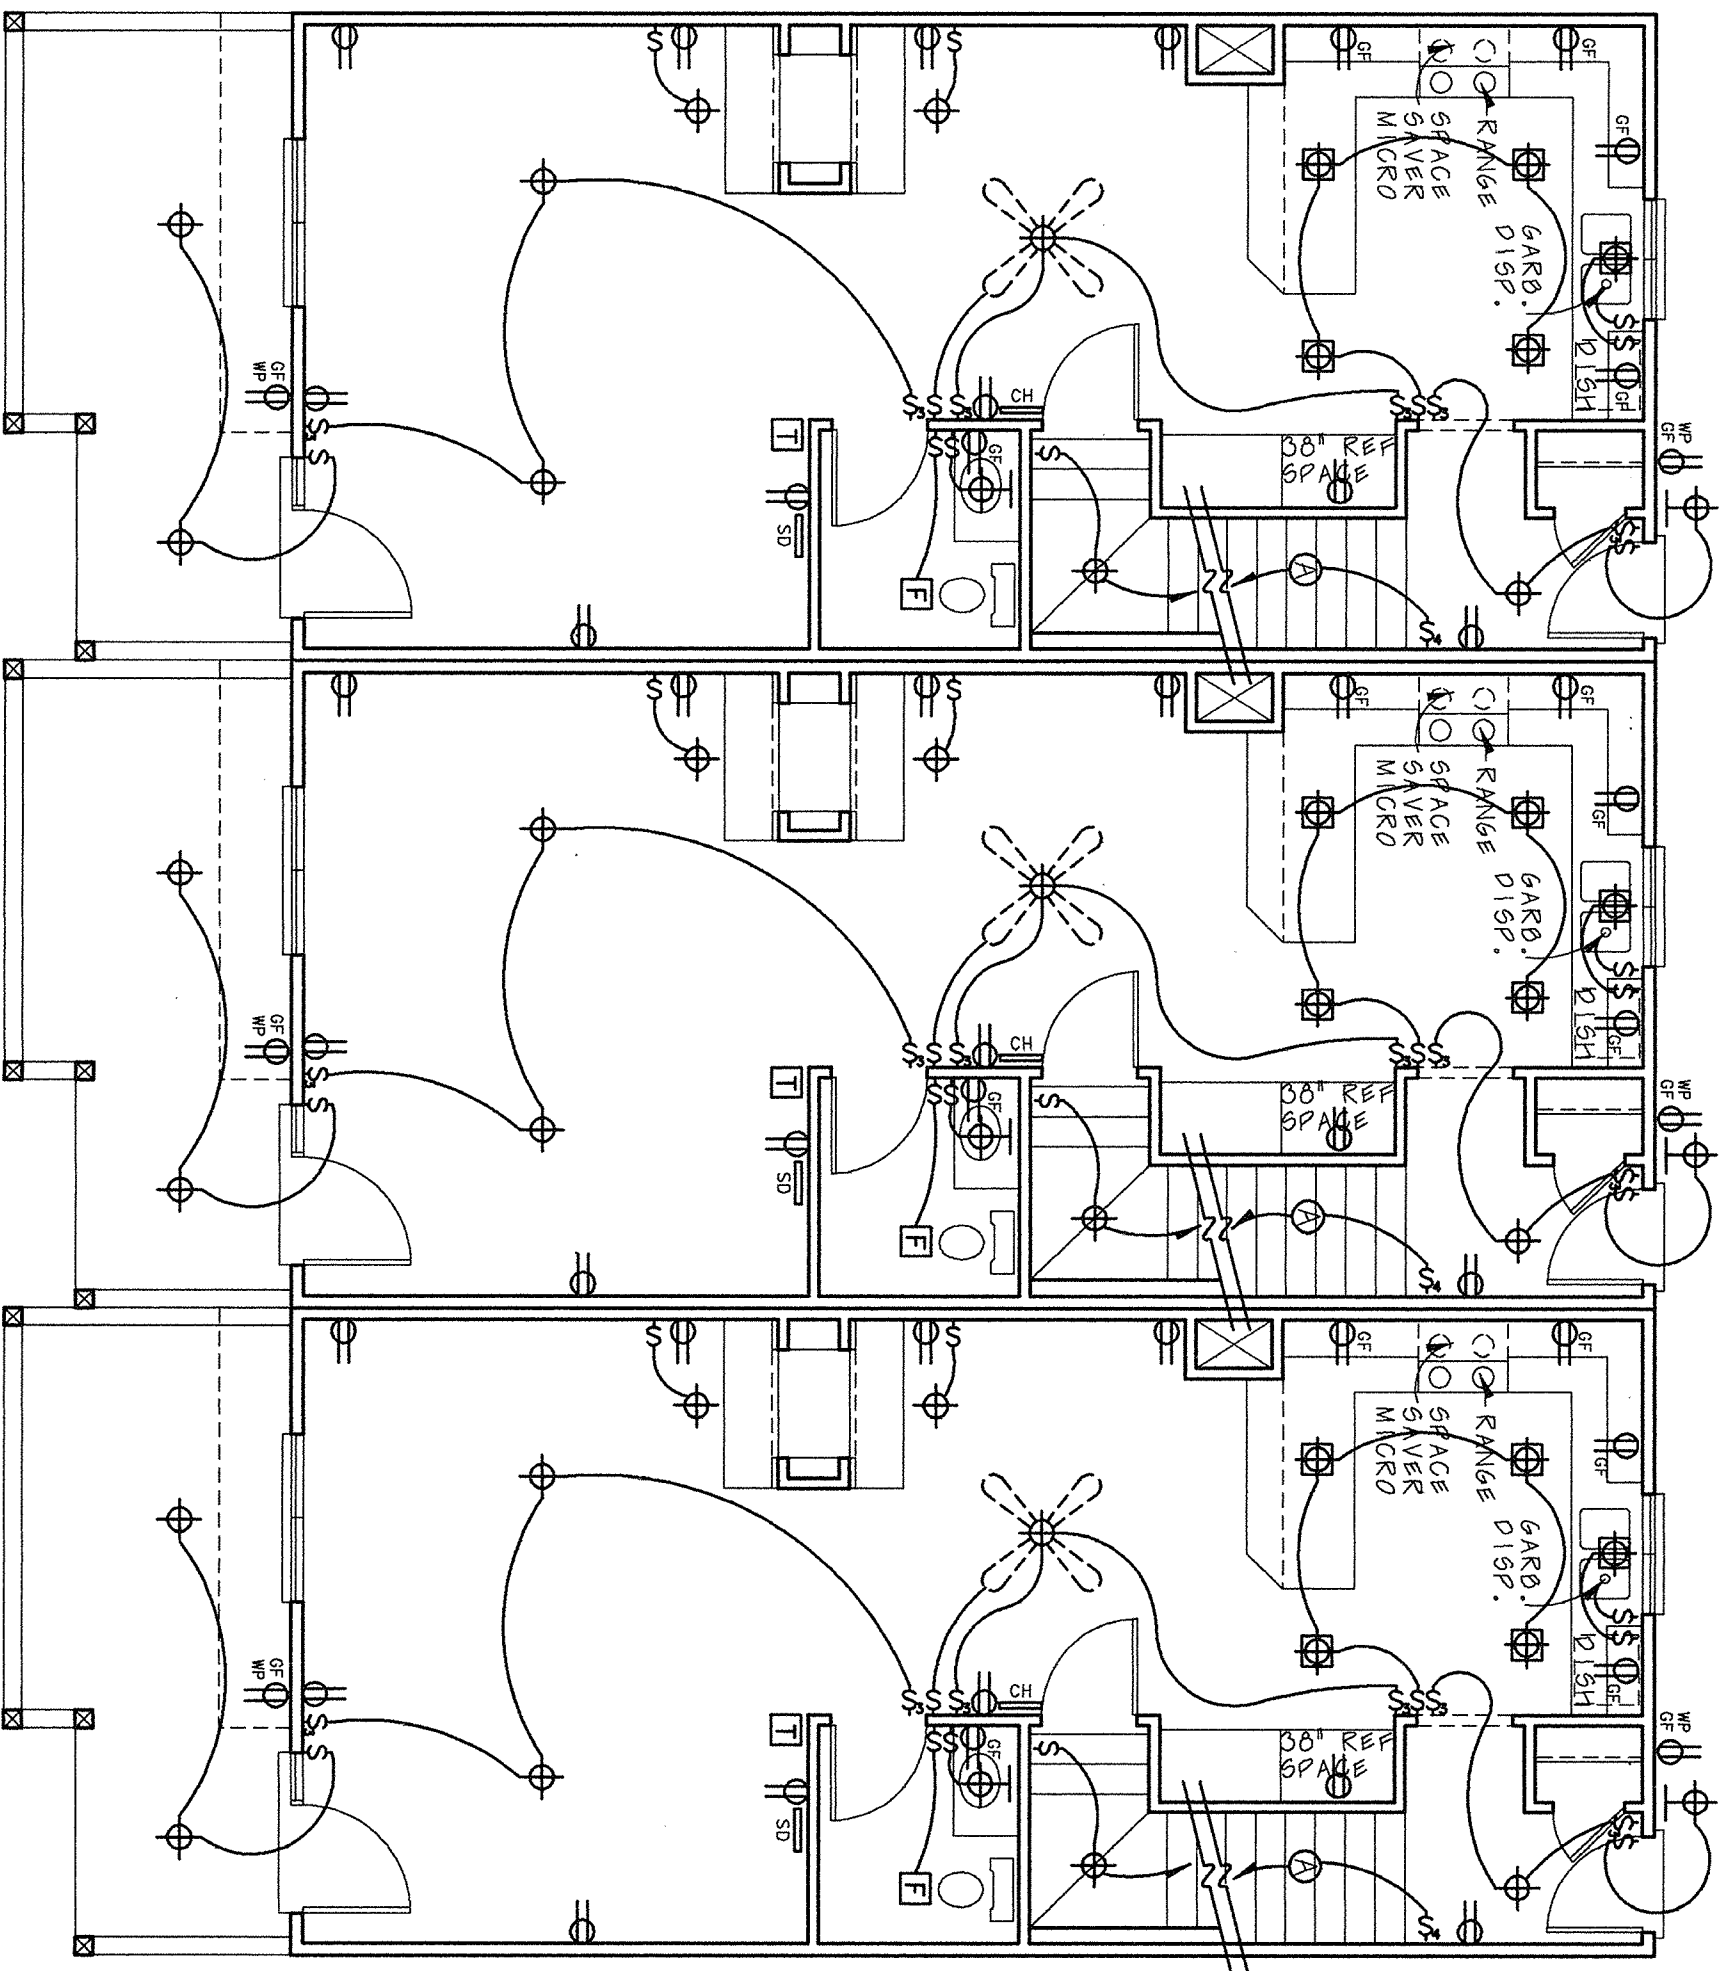



MAIN FLOOR ELECTRICAL

SCALE: 3/16" = 1'-0"

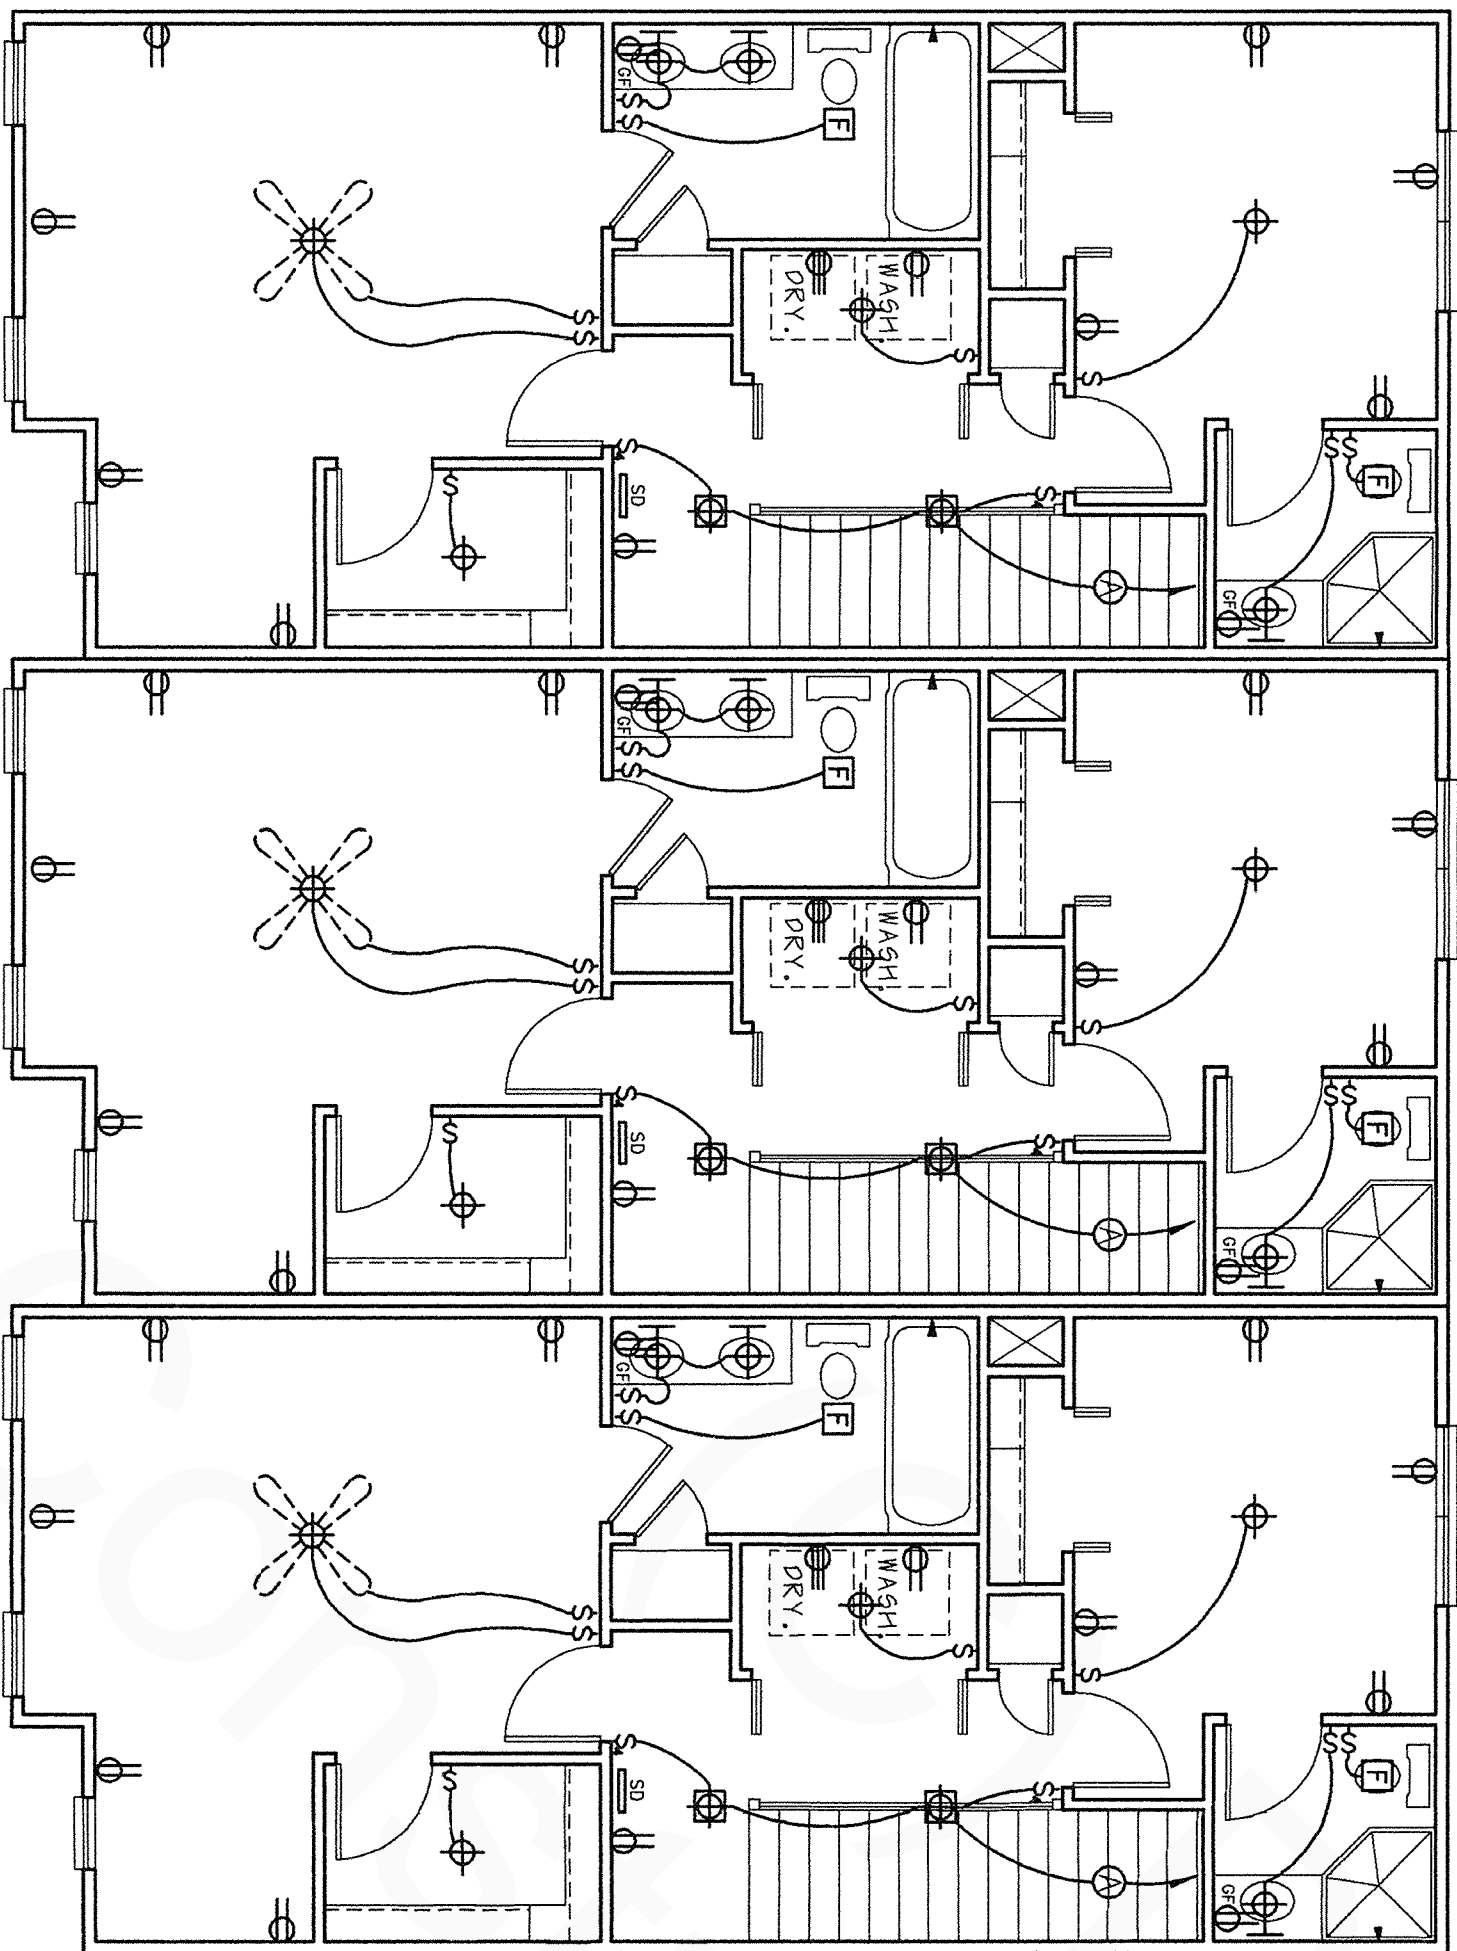

SECOND FLOOR ELECTRICAL

SCALE: 3/16" = 1'-0"

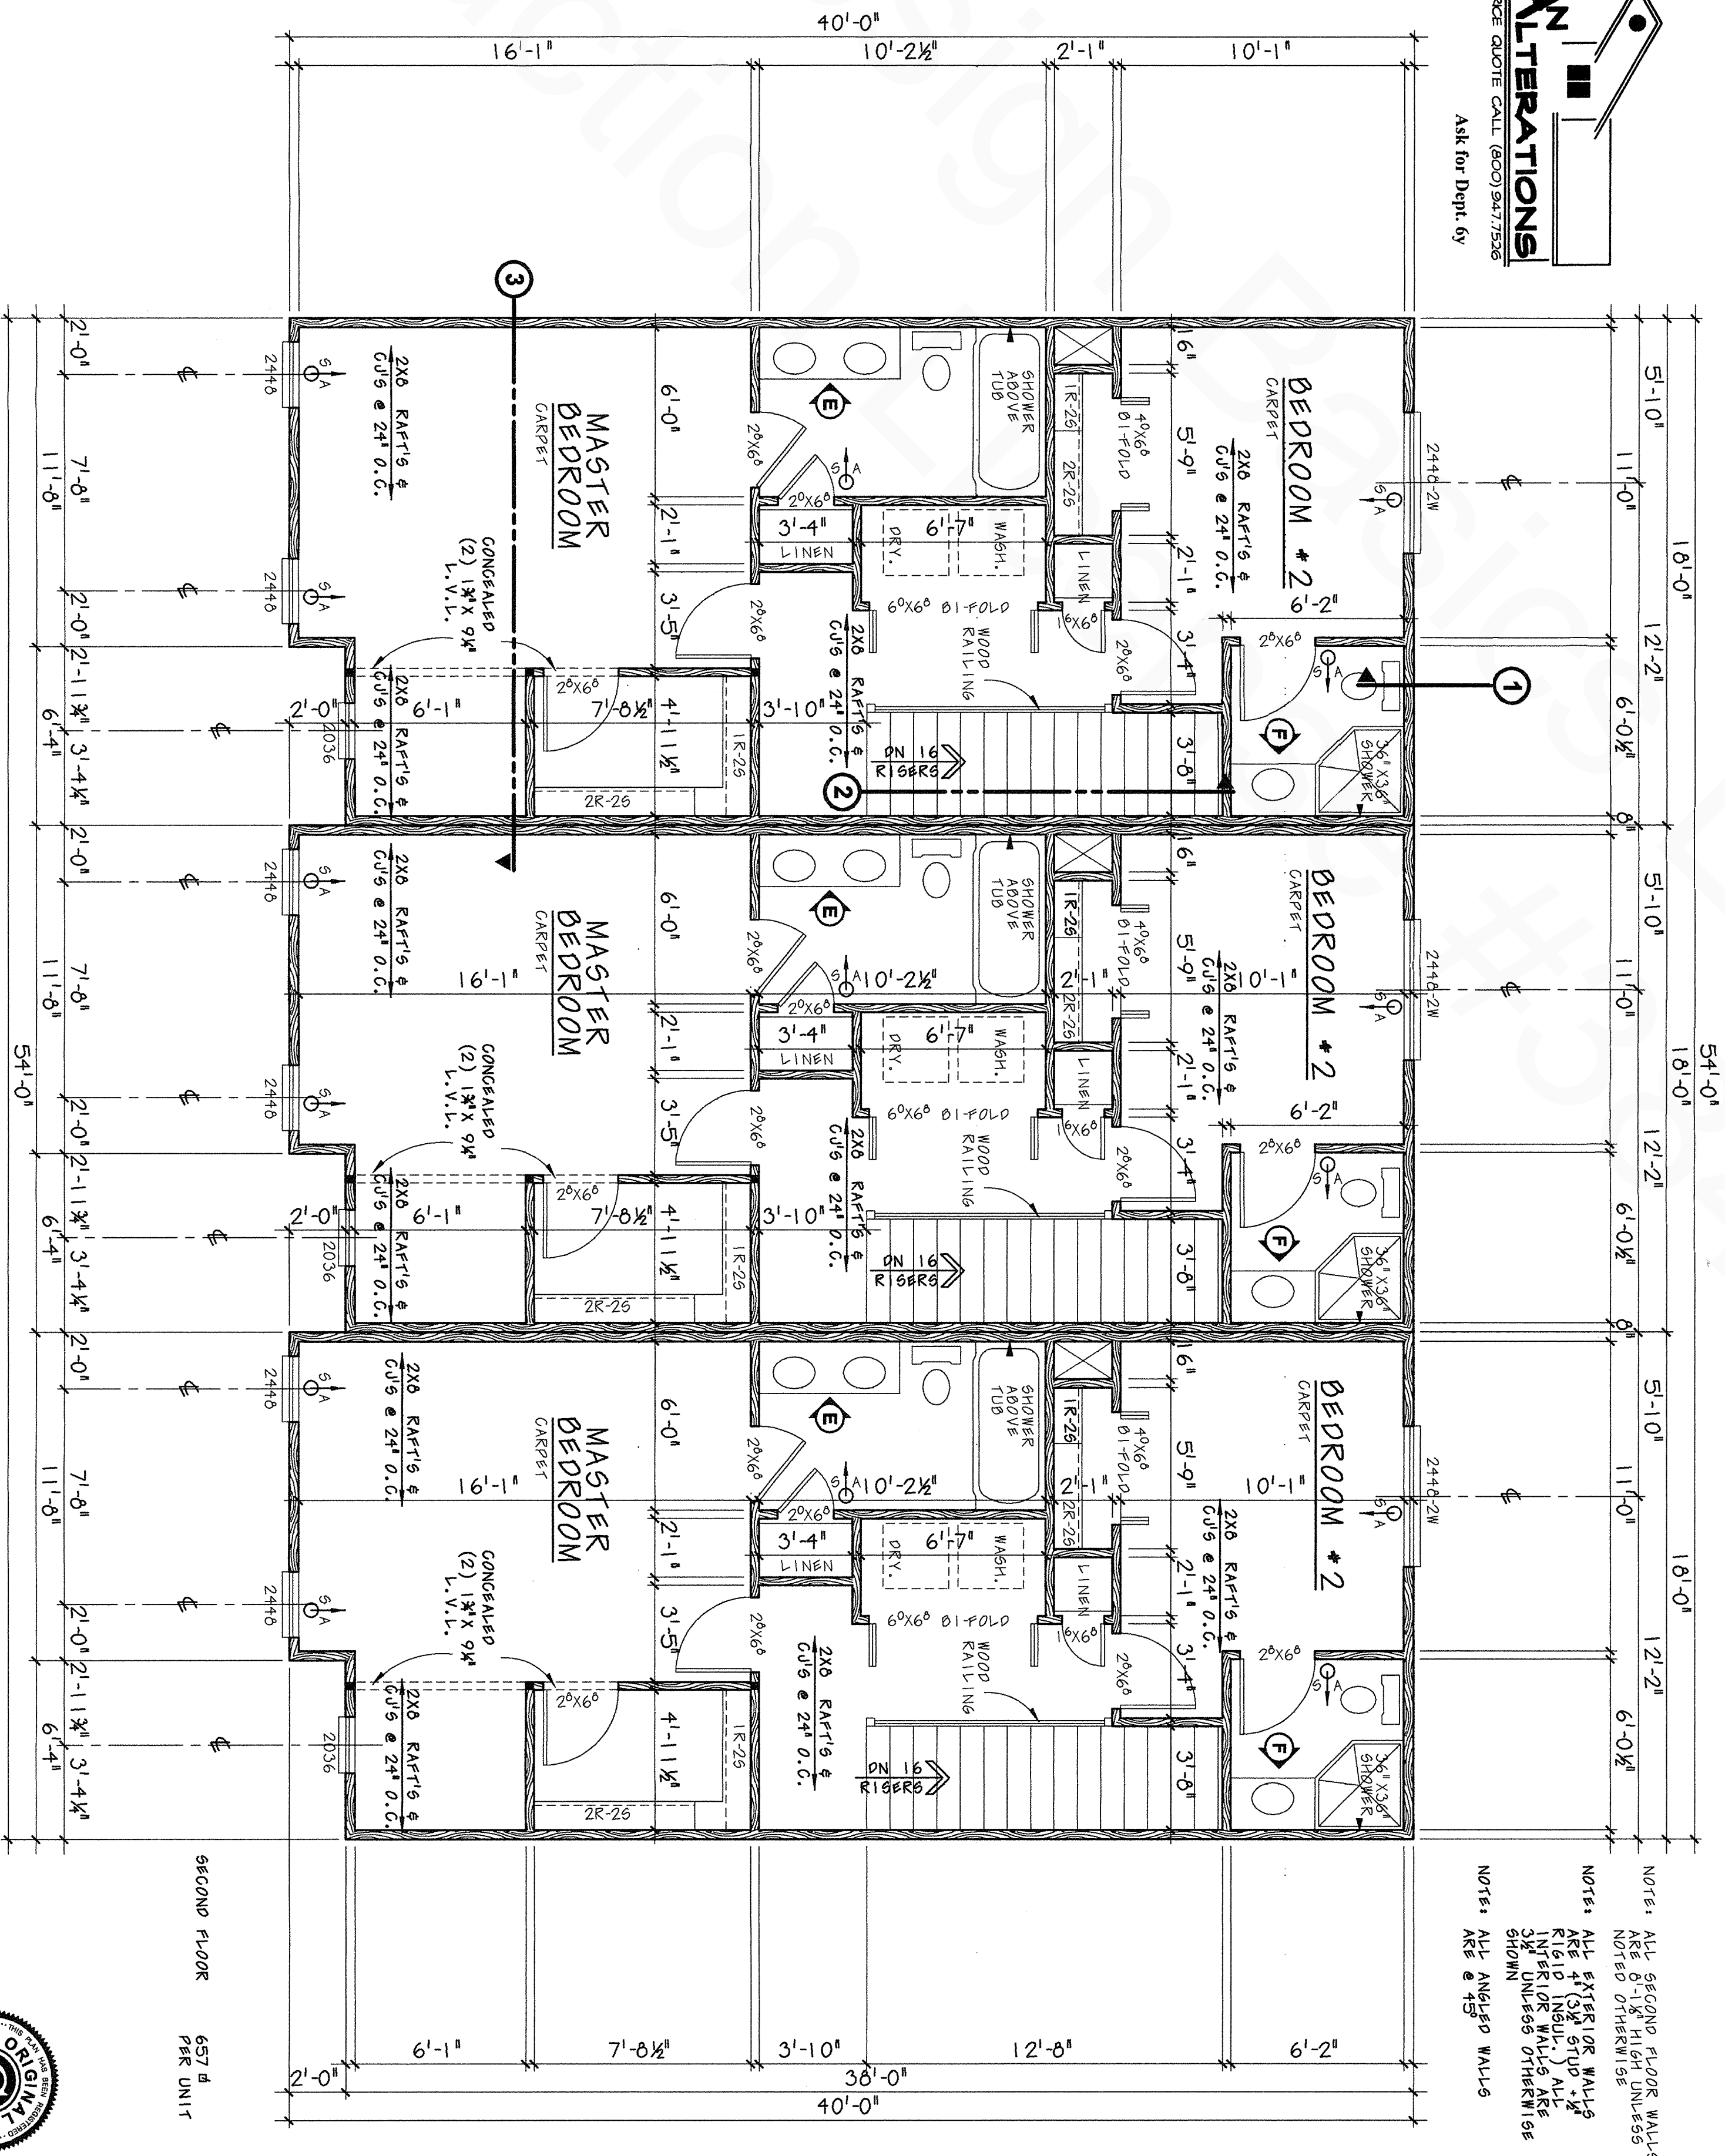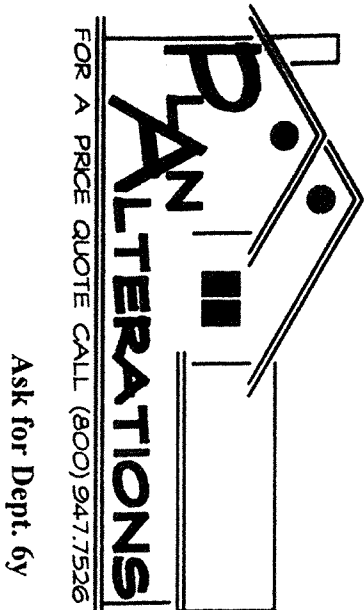

SECOND FLOOR PLAN


SCALE: 1/4" = 1'-0"

SECOND FLOOR
PER UNIT

NOTES: ALL SECOND FLOOR WALLS
NOTED OTHERWISE


NOTES: ALL EXTERIOR WALLS
RIGID INSULATION
INTERIOR WALLS ARE
SHOWN UNLESS OTHERWISE
NOTED

NOTES: ALL ANGLED WALLS

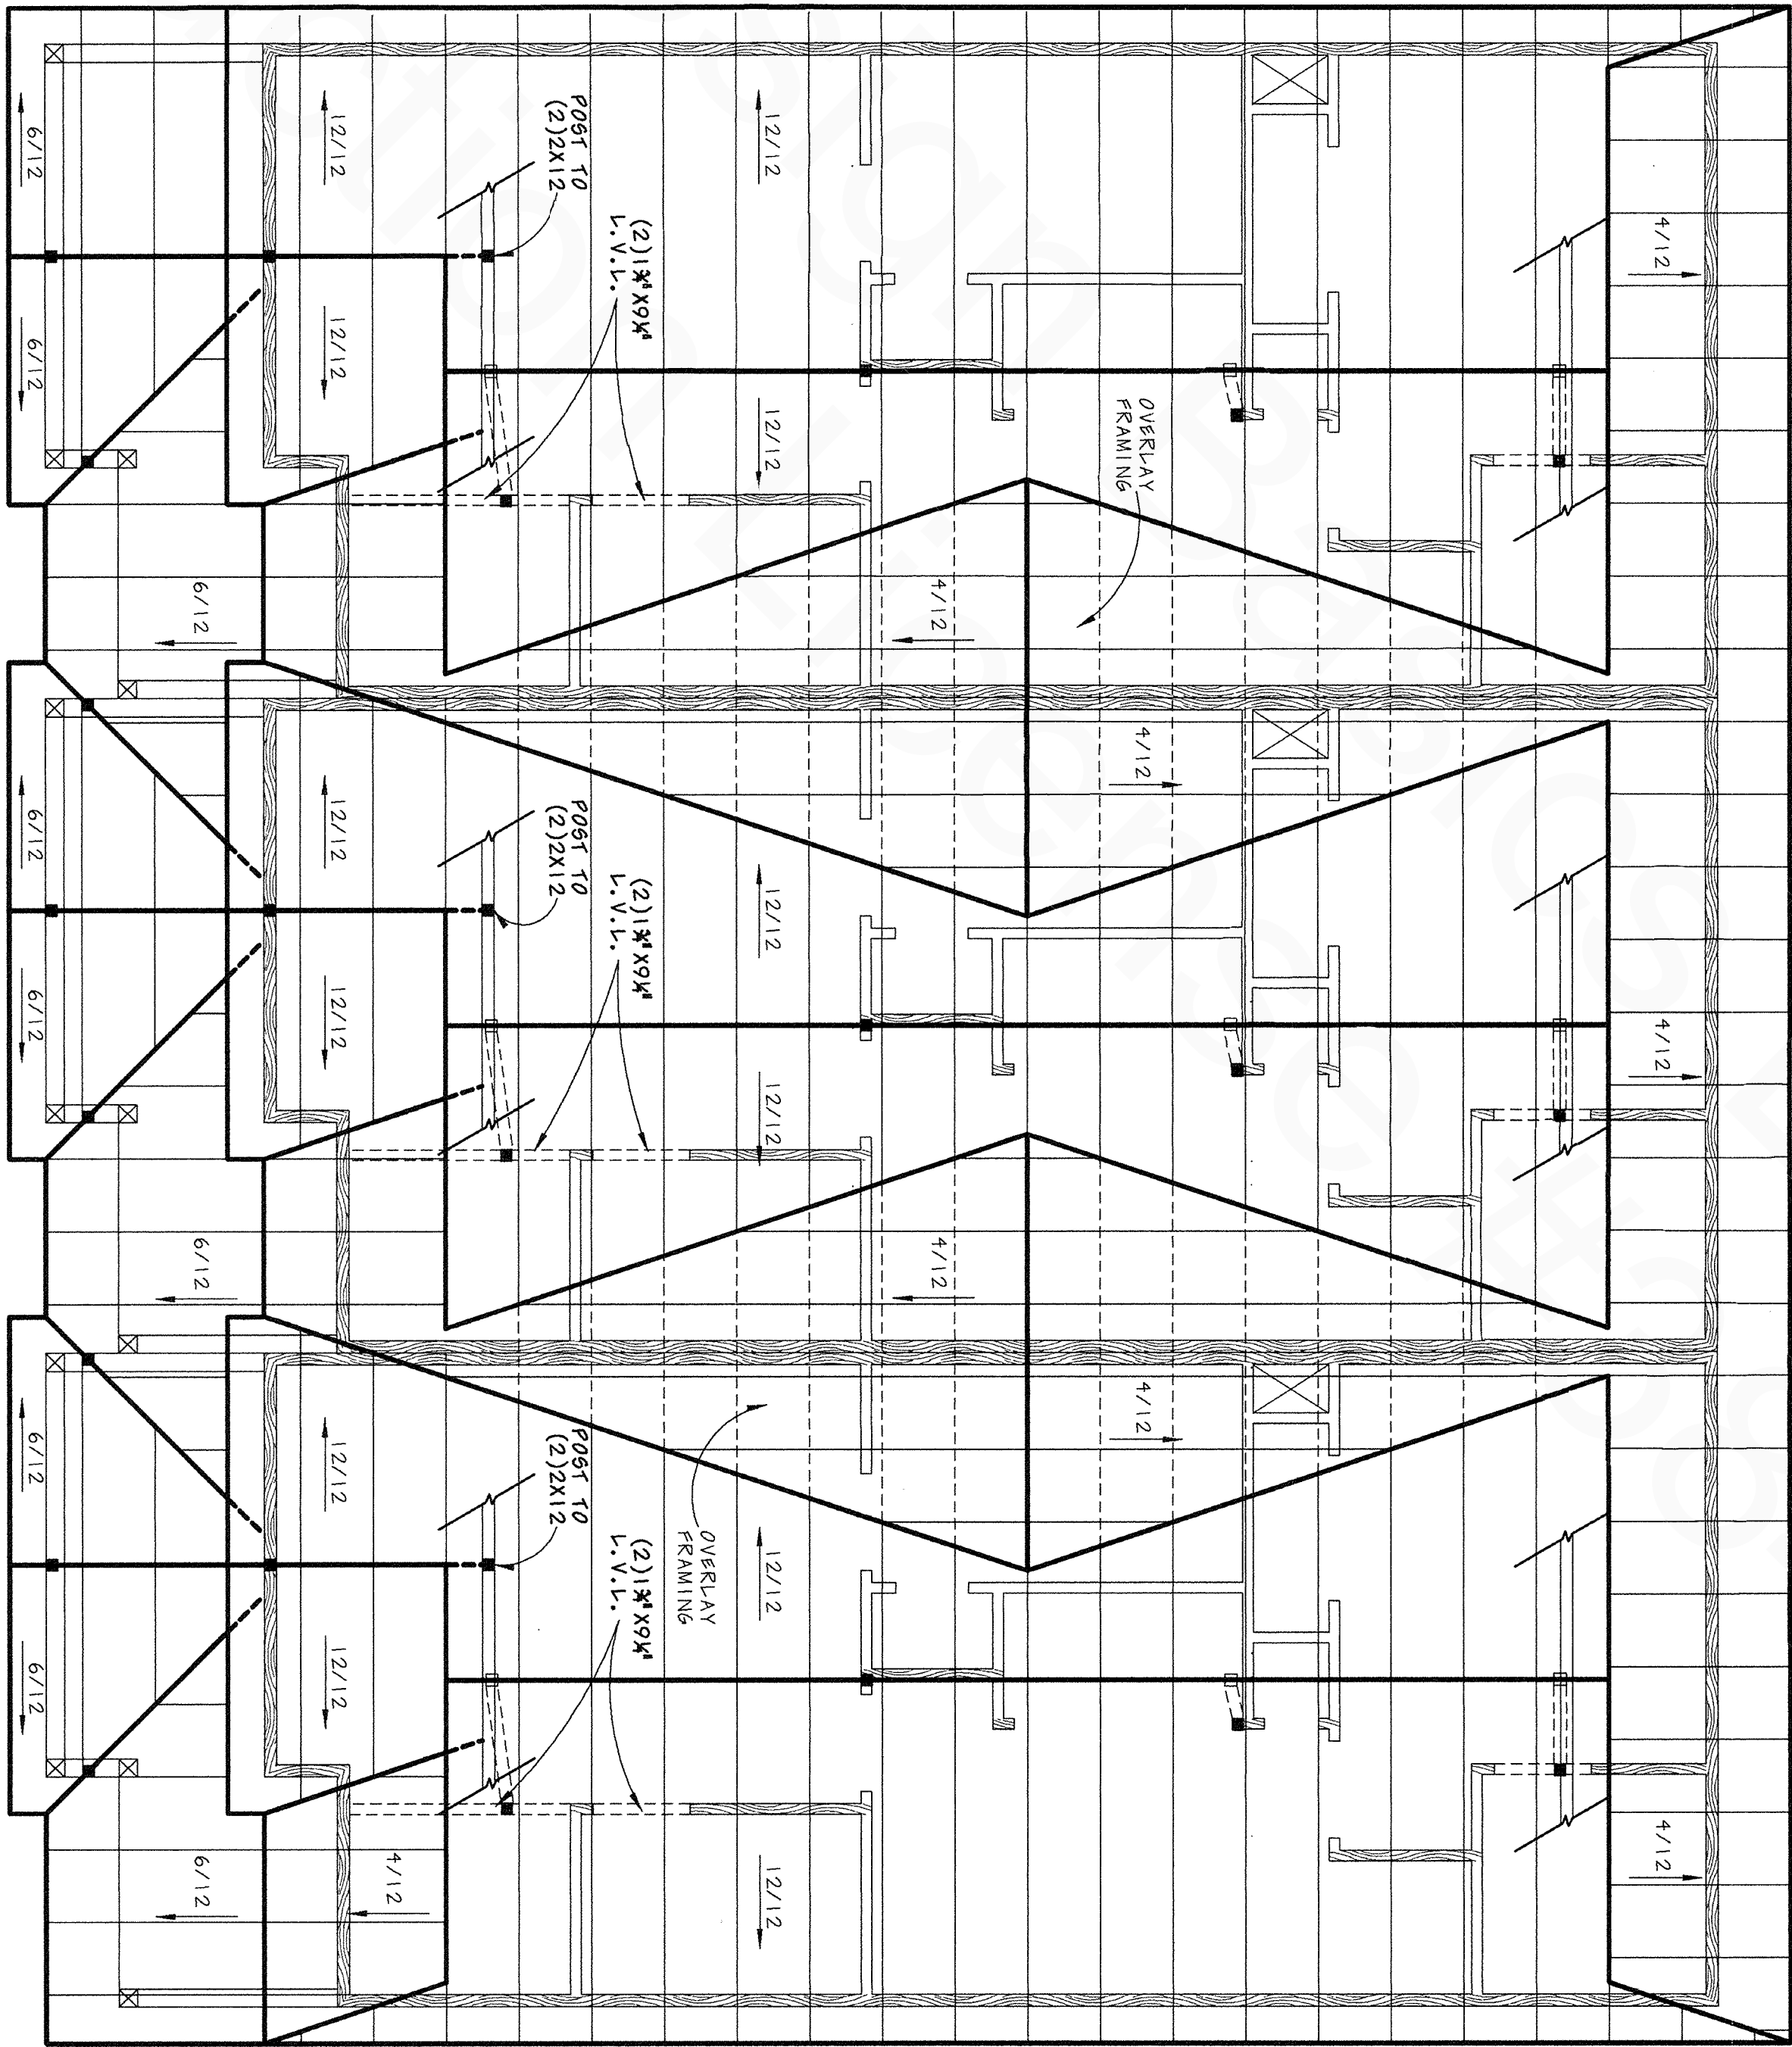

ROOF FRAMING PLAN

SCALE: 1/4" = 1'-0"

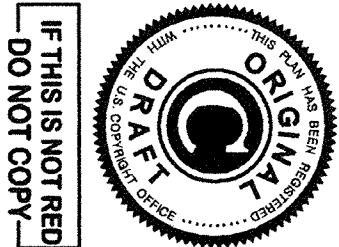

7228

DESIGN BASICS, INC. IS A PROFESSIONAL RESIDENTIAL DESIGN FIRM LOCATED IN OMAHA, NE. BECAUSE SITE CONDITIONS MAY VARY DESIGN BASICS, INC. CANNOT WARRANT THE SUITABILITY OF THESE PLANS FOR USE ON YOUR SPECIFIC SITE. CONSTRUCTION FROM THESE PLANS SHOULD NOT BE UNDERTAKEN WITHOUT THE ASSISTANCE OF A CONSTRUCTION PROFESSIONAL. THE PURCHASER OF THESE PLANS IS GIVEN A LIMITED LICENSE TO REPRODUCE THESE PLANS FOR CONSTRUCTION PURPOSES ONLY AND FURTHER DISTRIBUTION IS STRICTLY PROHIBITED.

© 2001

design basics inc.
HOME PLAN DESIGN SERVICE

RR
REVERSE
AVAILABLE

11112 John Galt Blvd. Omaha, NE 68137-2384
Fax: (402) 331-5507 Toll Free: (800) 947-7626
www.designbasics.com

ALL
PLANS
Customizable